








CIRCUIT LEGEND	
SYMBOL	CIRCUIT NO.#
	101
	102
	103
	104
	105
	106

**DRAFT**

Philips Brothers Electrical Contractors Inc. 235 Sweet Spring Road Glenmoore, PA 19343 phone: 610-458-8578 fax: 610-458-8438	
<b>Electrical Distribution System          &amp; New Main Substation</b>	
Fort Indiantown Gap, Pennsylvania <b>Circuit Feeder Layout</b>	
Scale: None	Date: 03/26/2009
DRAWING NUMBER Overall Layout	Sheet: 1 of 8



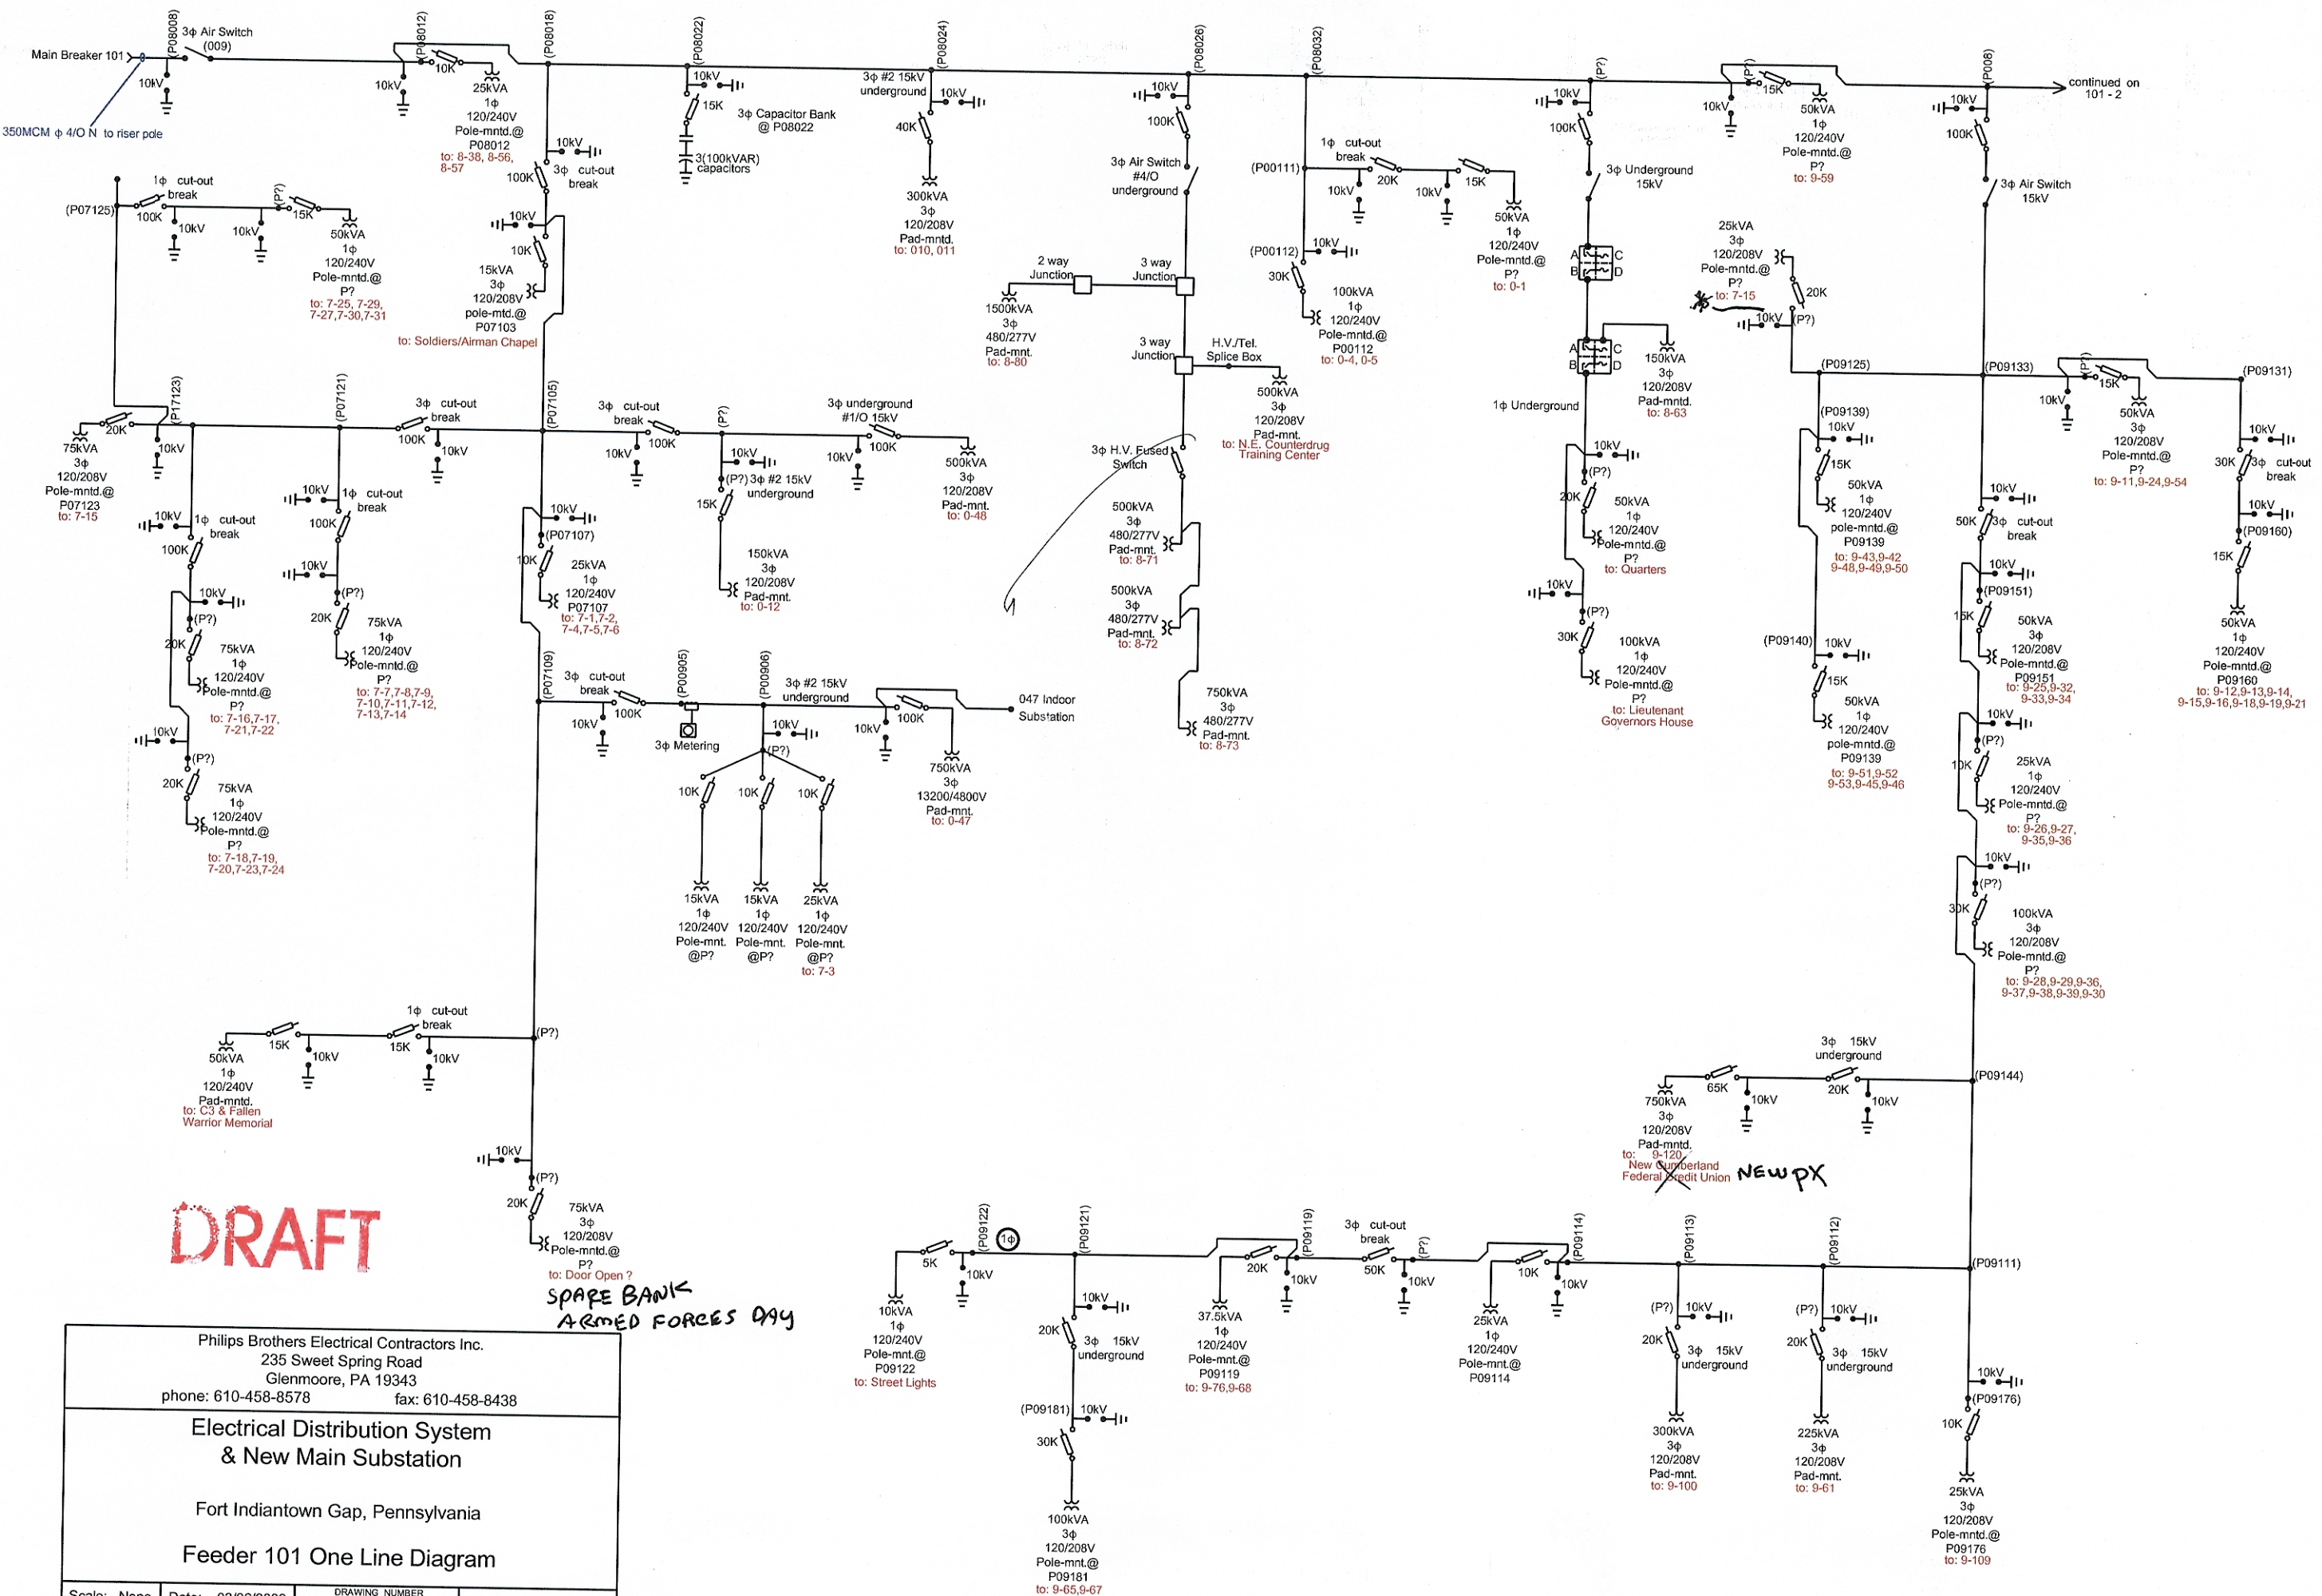


**DRAFT**

to: Door Open ?  
**SPARE BANK**  
**ARMED FORCES DAY**

Philips Brothers Electrical Contractors Inc. 235 Sweet Spring Road Glenmoore, PA 19343 phone: 610-458-8578    fax: 610-458-8438			
<b>Electrical Distribution System          &amp; New Main Substation</b>			
Fort Indiantown Gap, Pennsylvania <b>Feeder 101 One Line Diagram</b>			
Scale: None	Date: 03/26/2009	DRAWING NUMBER 101 - 1	Sheet: 2 of 8




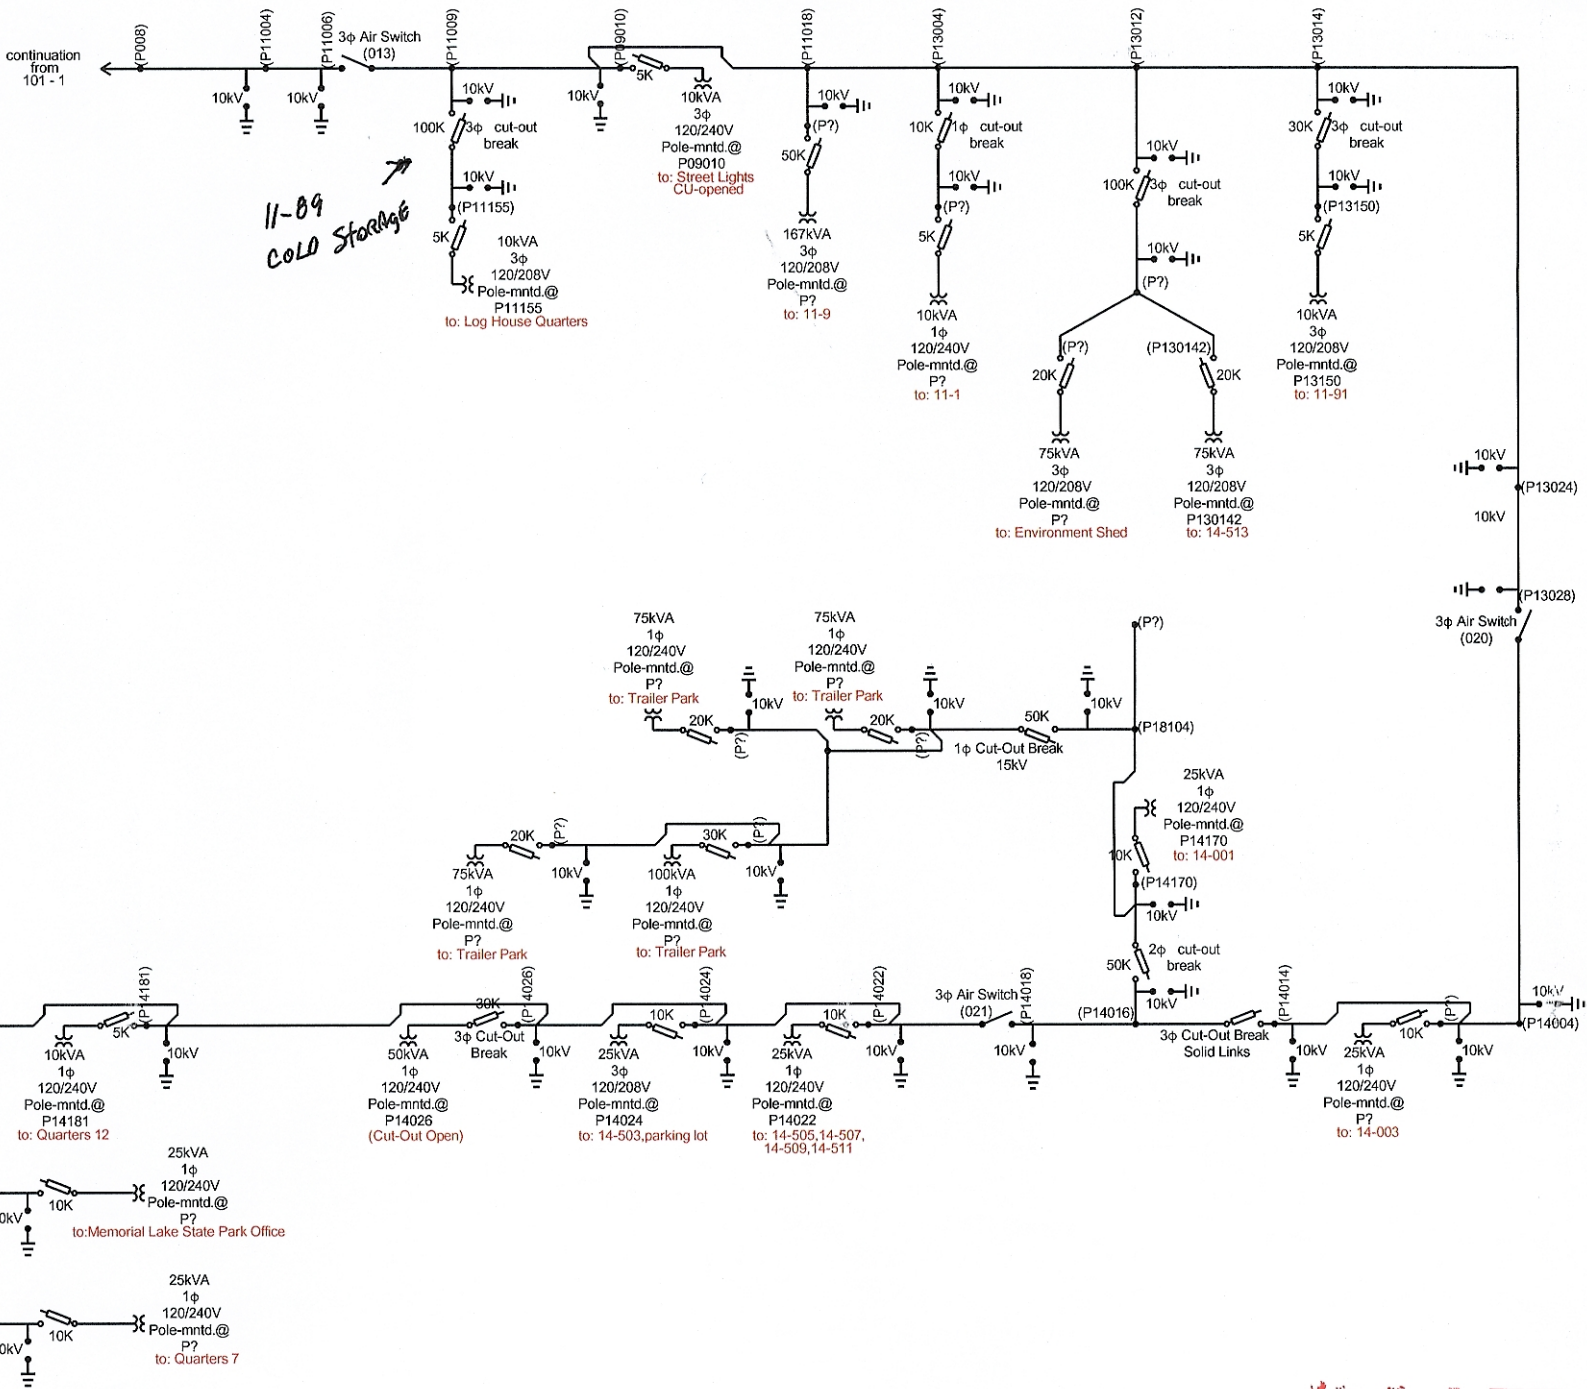

DRAFT

Phillips Brothers Electrical Contractors Inc. 235 Sweet Spring Road Glenmoore, PA 19343 phone: 610-458-8578      fax: 610-458-8438			
<h3>Electrical Distribution System &amp; New Main Substation</h3>			
Fort Indiantown Gap, Pennsylvania			
<h3>Feeder 101 One Line Diagram</h3>			
Scale: None	Date: 03/26/2009	DRAWING NUMBER 101 - 2	Sheet: 3 of 8




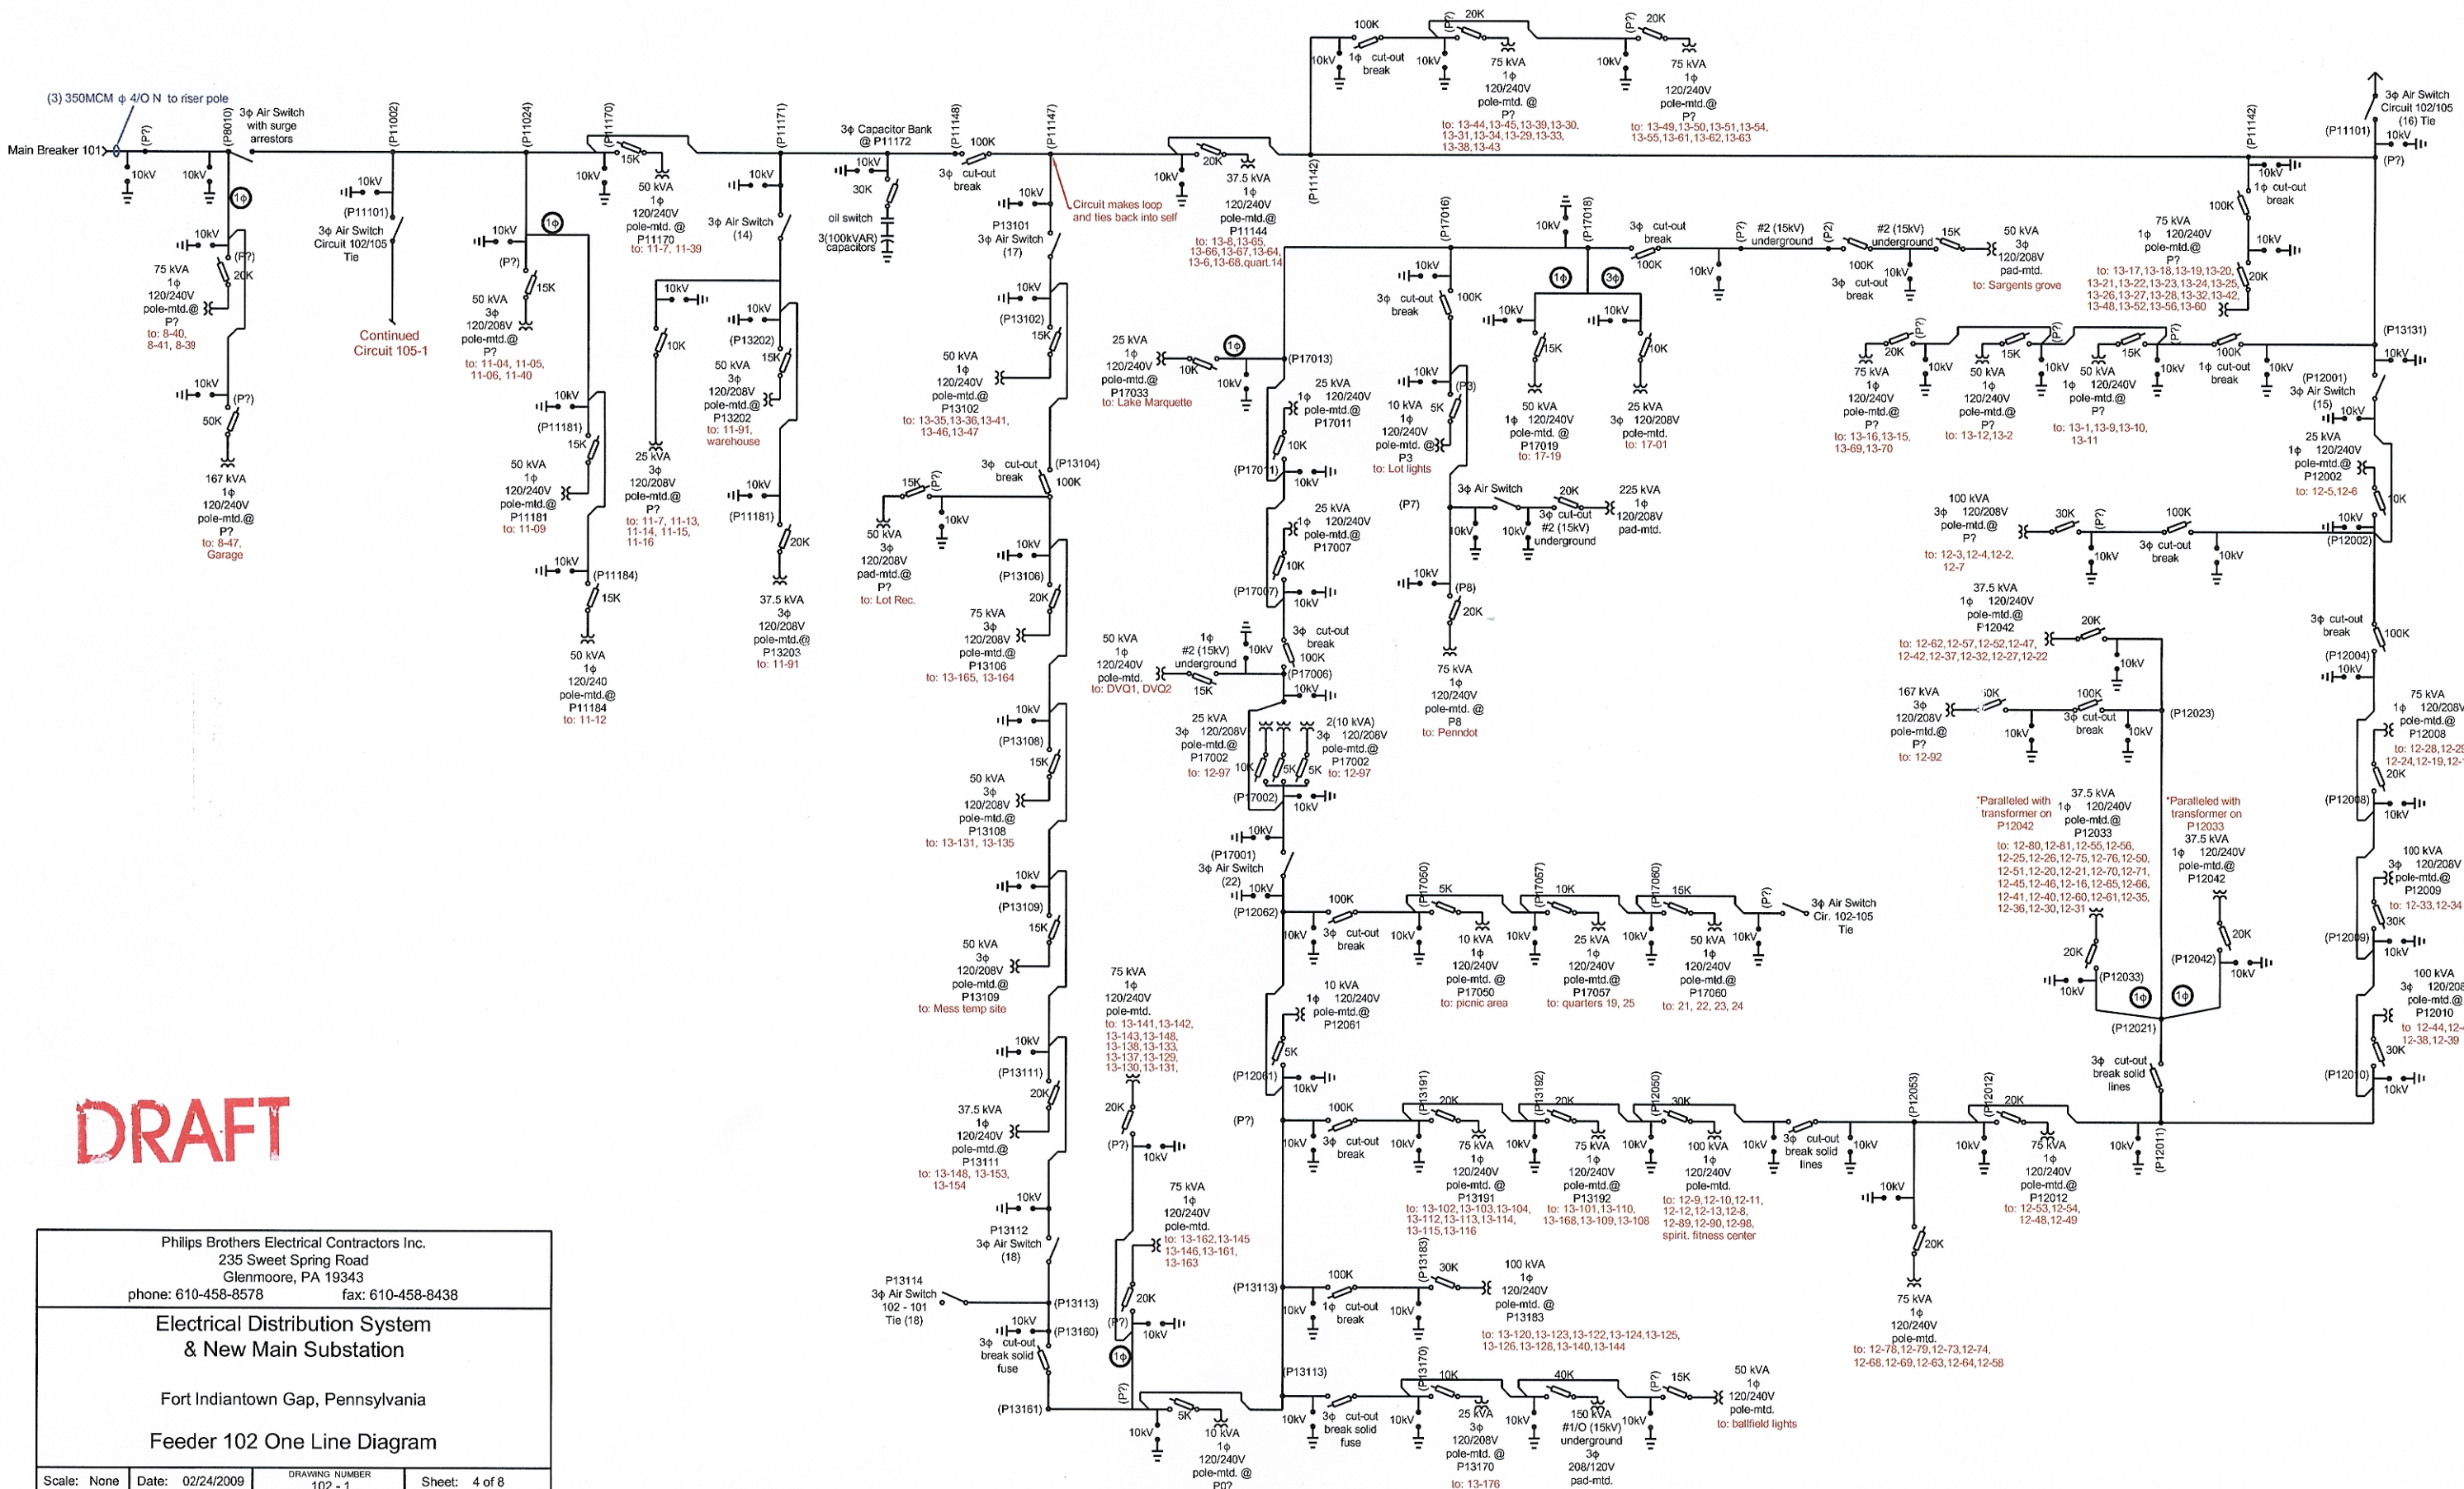

**DRAFT**

Philips Brothers Electrical Contractors Inc. 235 Sweet Spring Road Glenmoore, PA 19343 phone: 610-458-8578 fax: 610-458-8438			
<b>Electrical Distribution System &amp; New Main Substation</b>			
Fort Indiantown Gap, Pennsylvania <b>Feeder 102 One Line Diagram</b>			
Scale: None	Date: 02/24/2009	DRAWING NUMBER 102 - 1	Sheet: 4 of 8




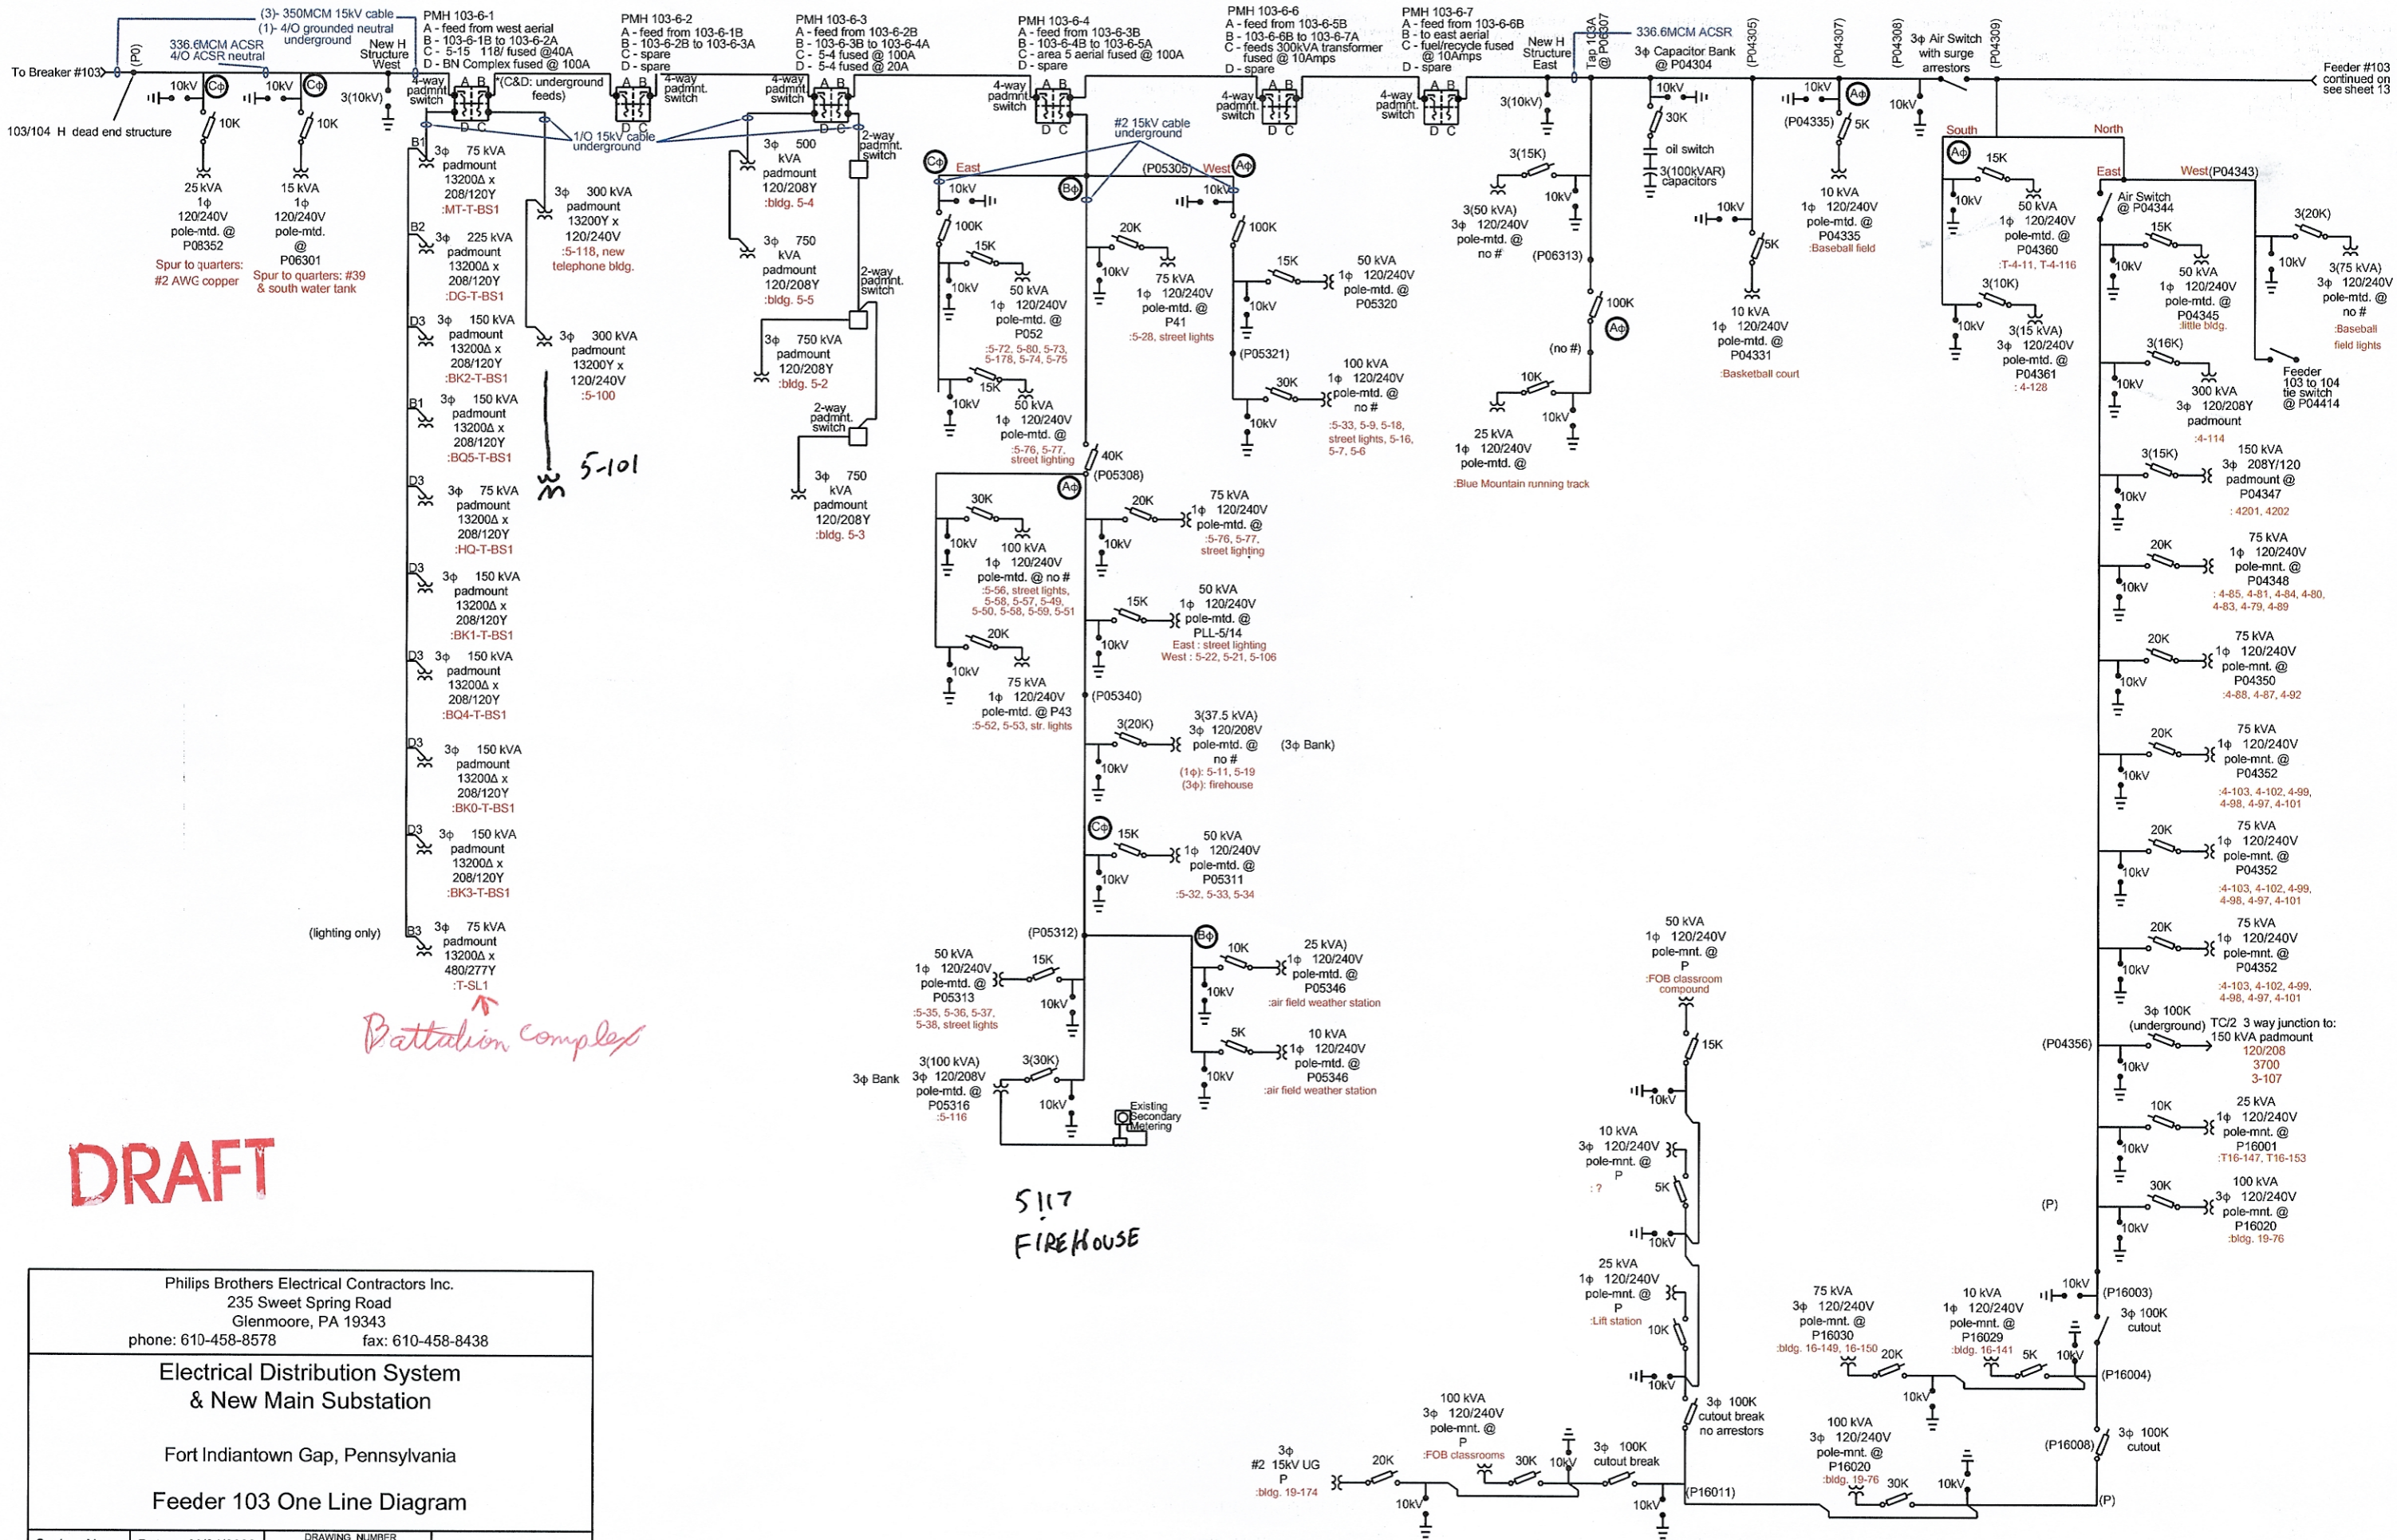

**DRAFT**

Philips Brothers Electrical Contractors Inc. 235 Sweet Spring Road Glenmoore, PA 19343 phone: 610-458-8578    fax: 610-458-8438			
<b>Electrical Distribution System &amp; New Main Substation</b>			
Fort Indiantown Gap, Pennsylvania <b>Feeder 103 One Line Diagram</b>			
Scale: None	Date: 02/24/2009	DRAWING NUMBER 103 - 1	Sheet: 5 of 8




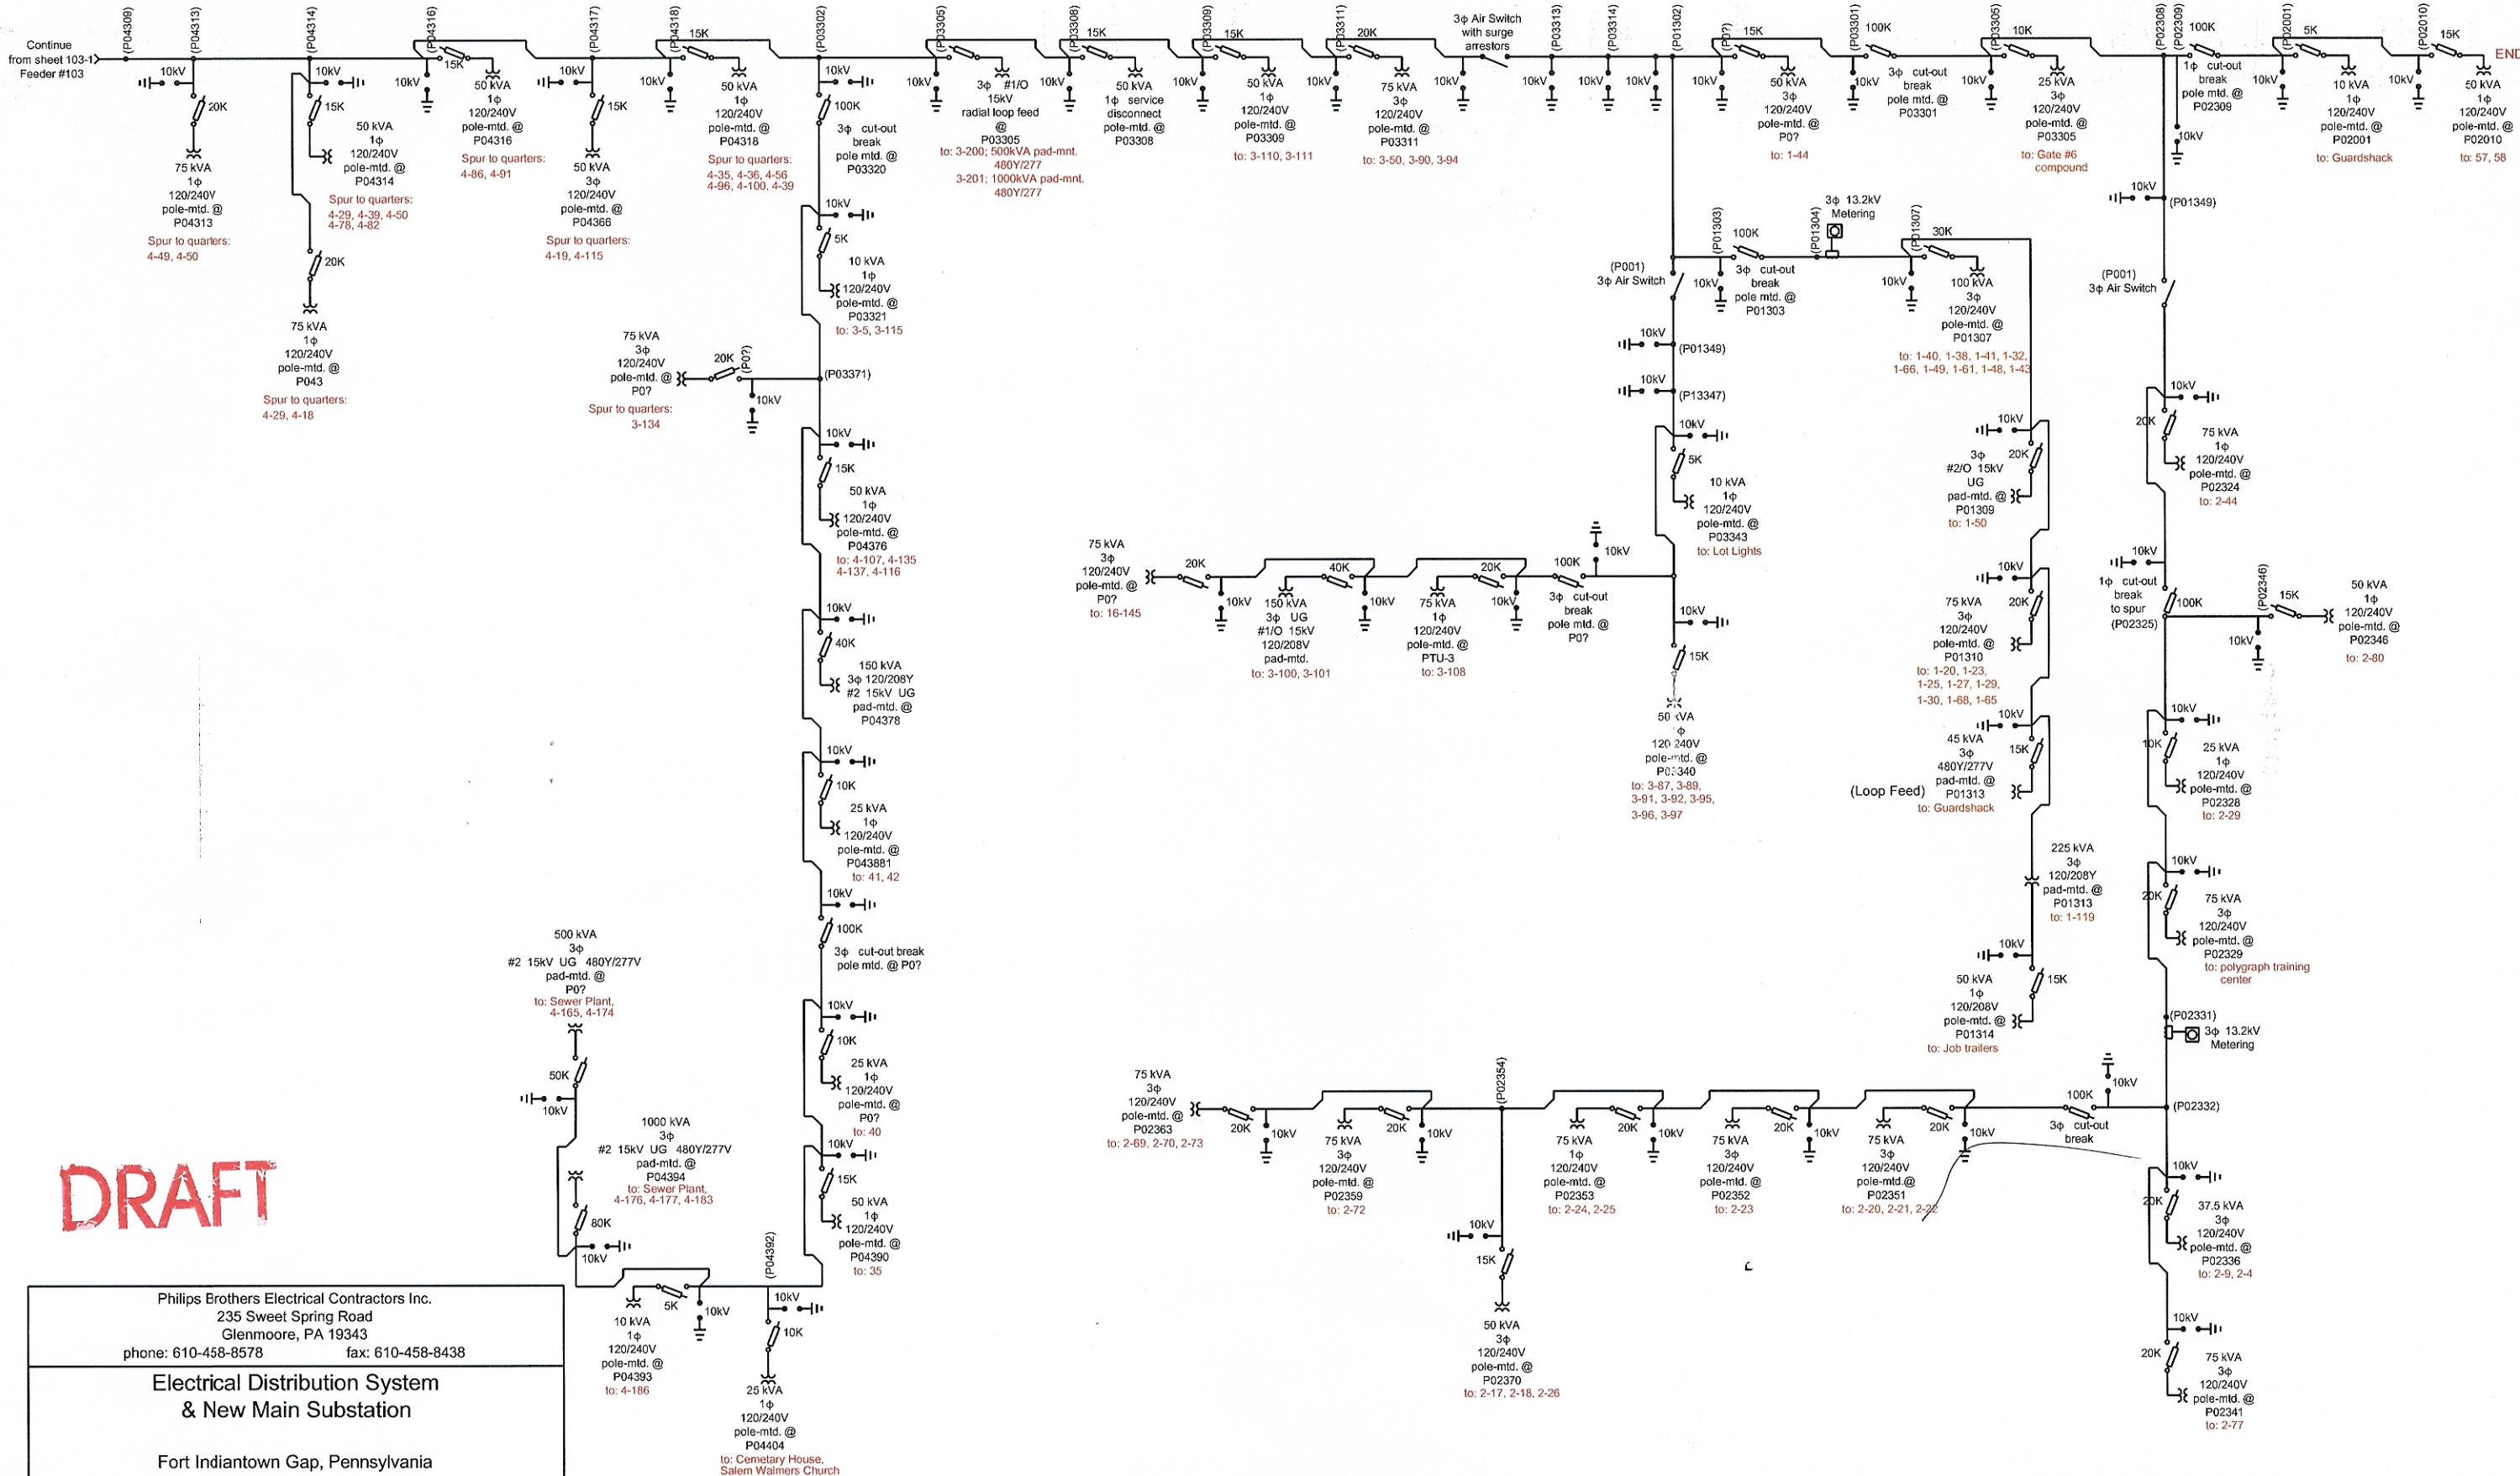

**DRAFT**

Philips Brothers Electrical Contractors Inc. 235 Sweet Spring Road Glenmoore, PA 19343 phone: 610-458-8578 fax: 610-458-8438			
<b>Electrical Distribution System          &amp; New Main Substation</b>			
Fort Indiantown Gap, Pennsylvania <b>Feeder 103 One Line Diagram</b>			
Scale: None	Date: 02/24/2009	DRAWING NUMBER 103 - 2	Sheet: 6 of 8



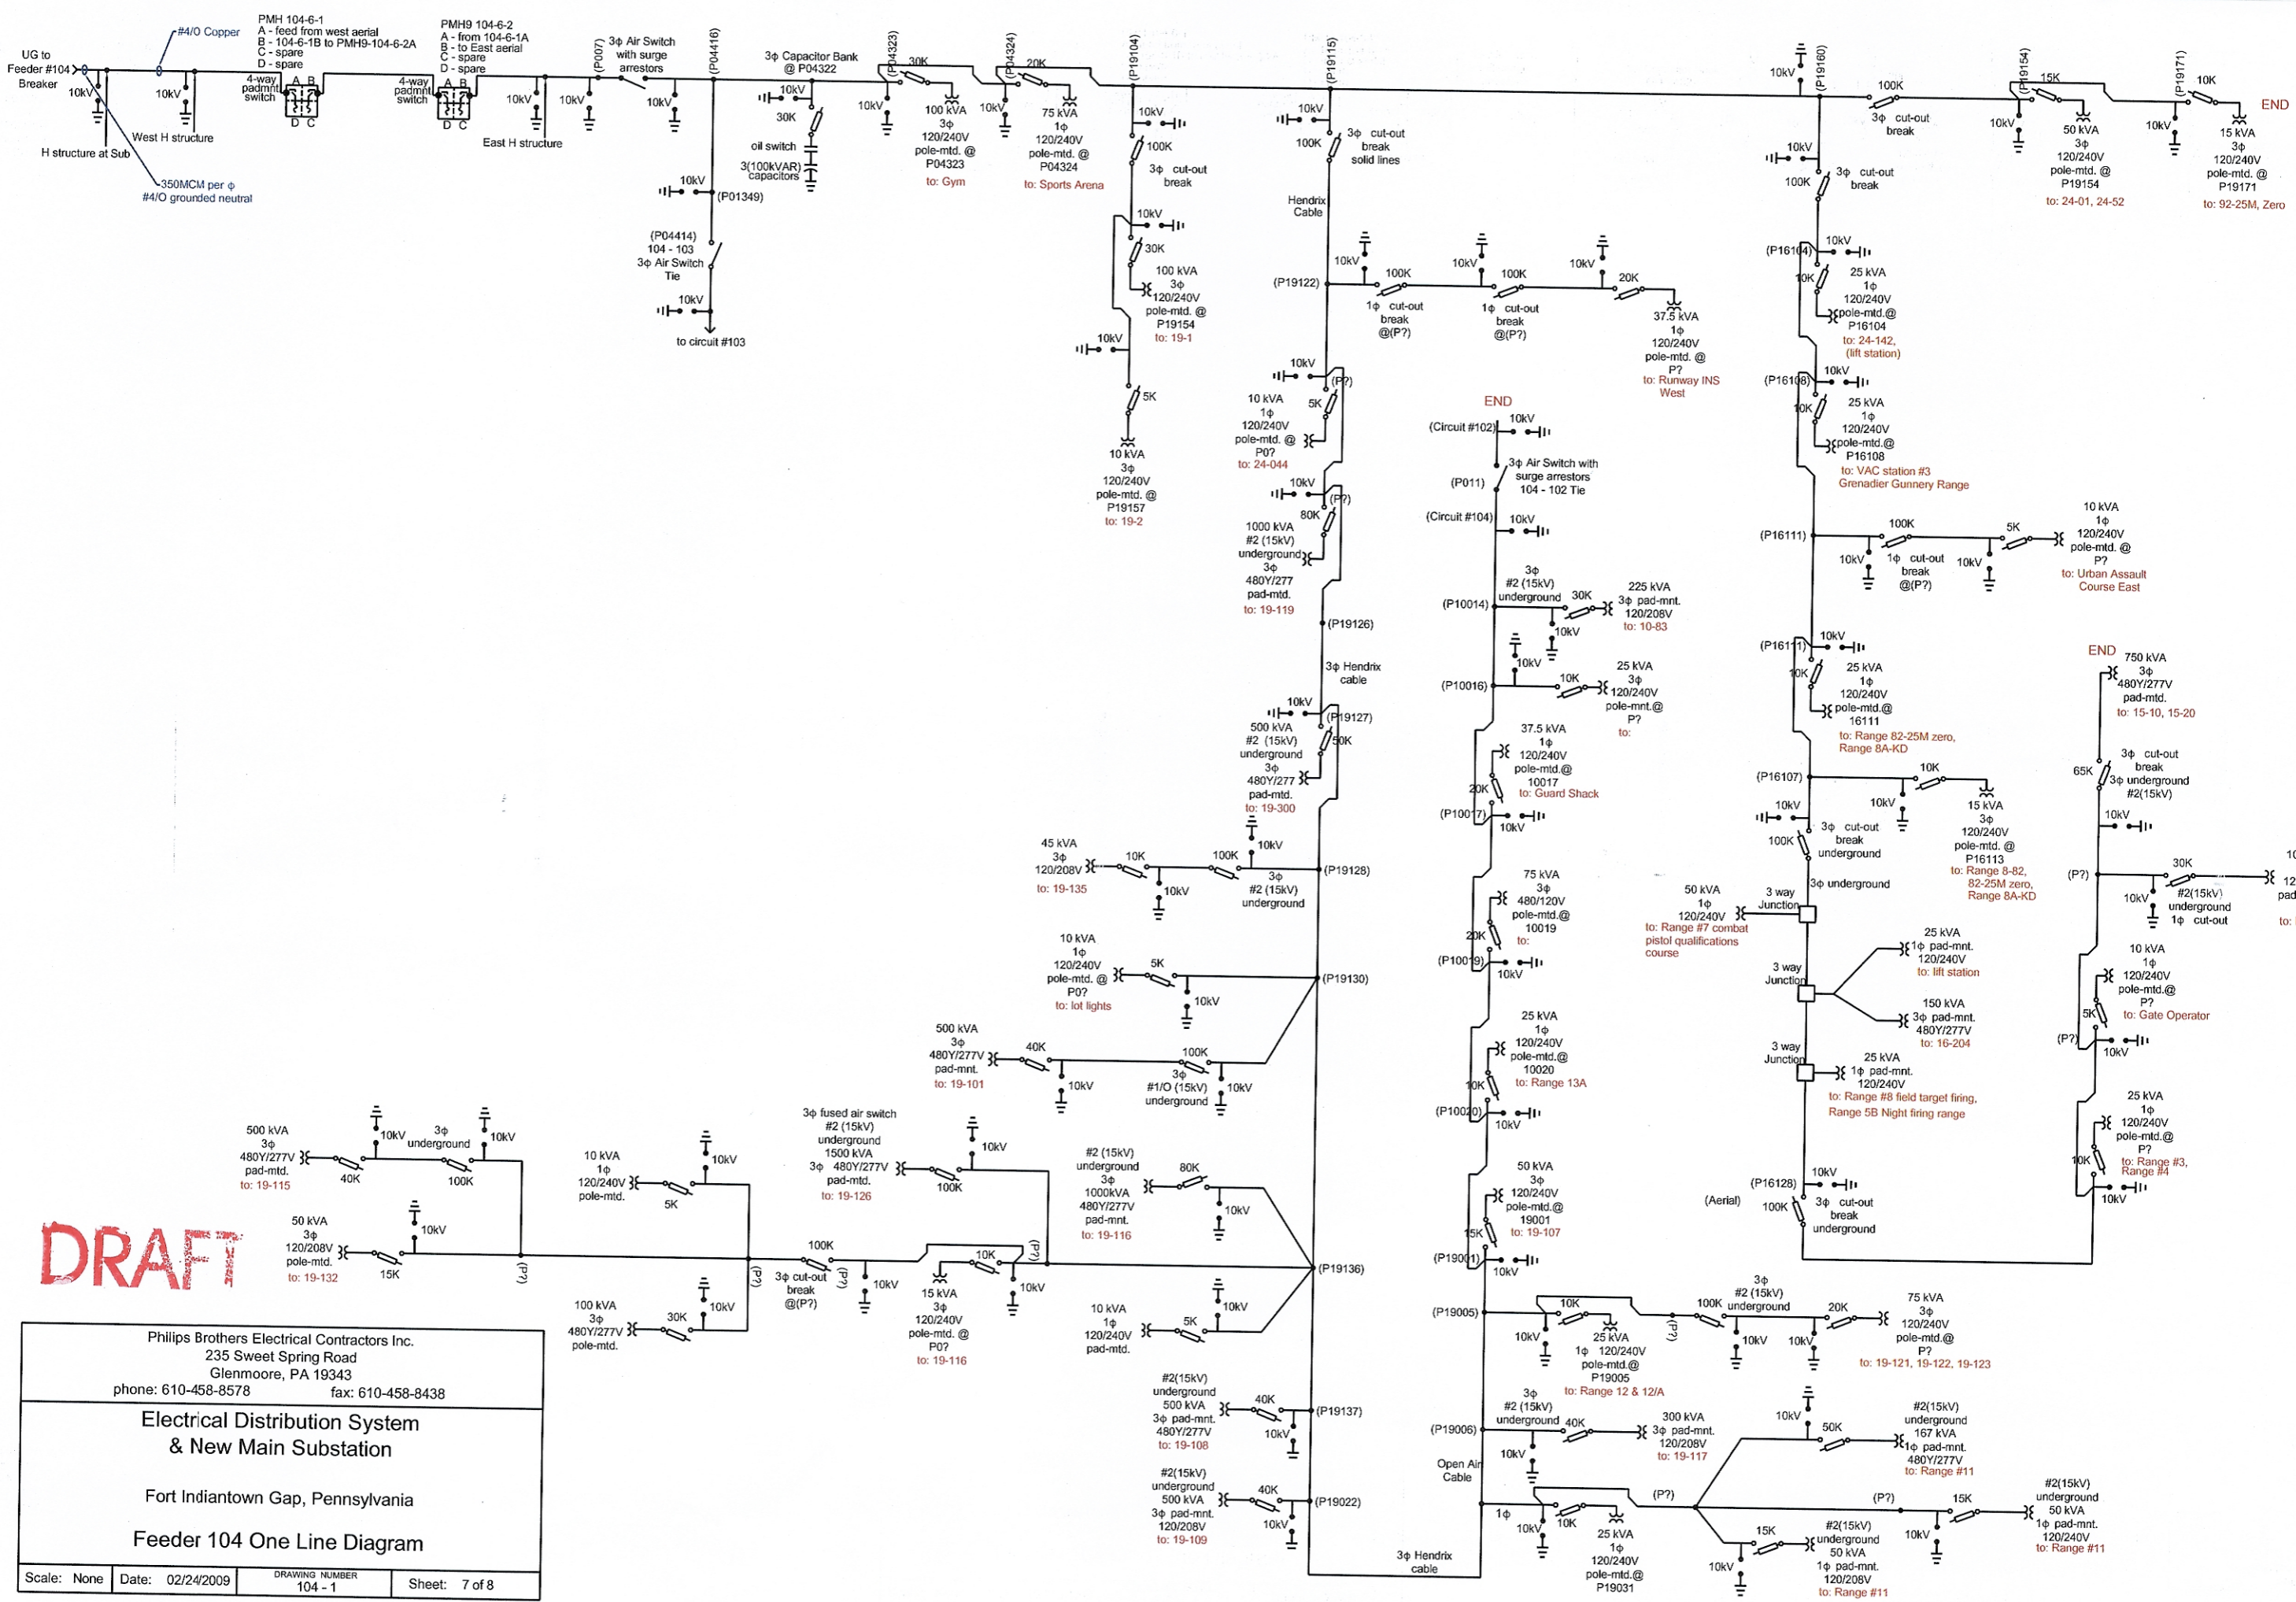

**DRAFT**

Philips Brothers Electrical Contractors Inc. 235 Sweet Spring Road Glenmoore, PA 19343 phone: 610-458-8578 fax: 610-458-8438			
<b>Electrical Distribution System &amp; New Main Substation</b>			
Fort Indiantown Gap, Pennsylvania			
<b>Feeder 104 One Line Diagram</b>			
Scale: None	Date: 02/24/2009	DRAWING NUMBER 104 - 1	Sheet: 7 of 8



