
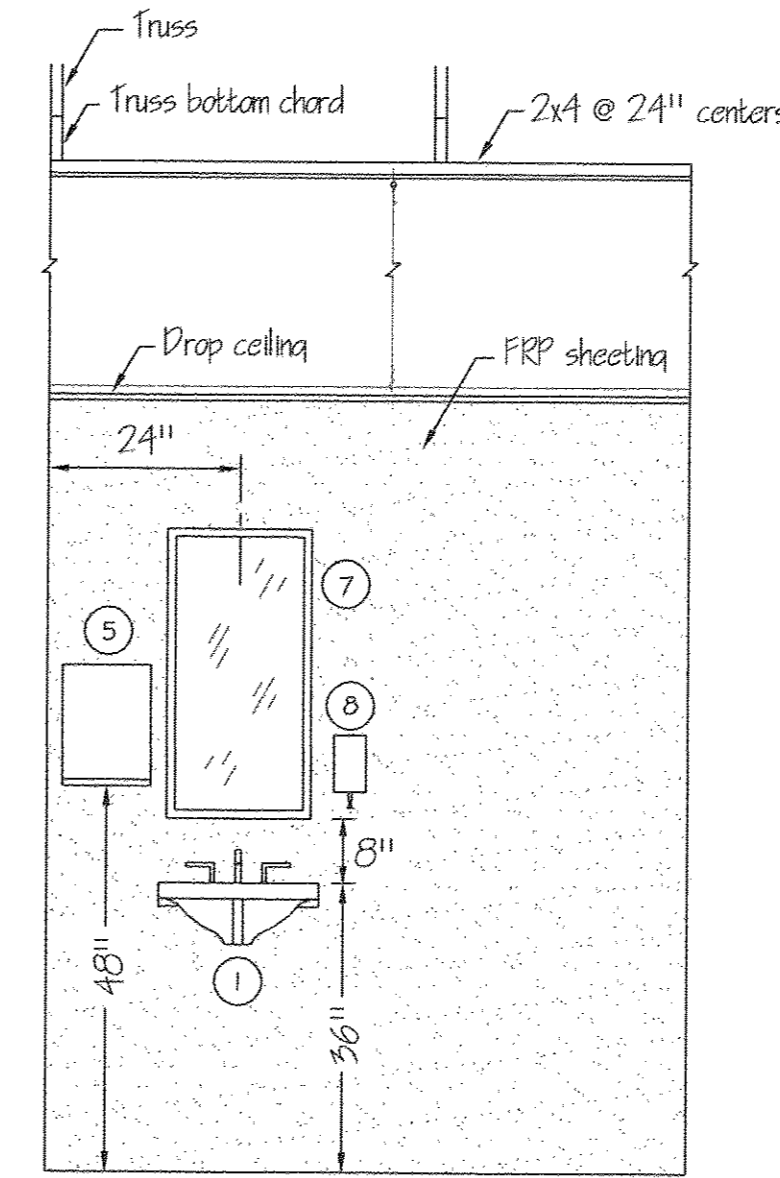


WATER SUPPLY ISOMETRIC
NO SCALE



BRADLEY CORP. (FOR REF. ONLY)
FIXTURE/ACCESSORY LEGEND

- ① SINK (W/FAUCET)
- ② FLOOR MOUNTED WATER CLOSET
- ③ GRAB BAR (24" LONG)
- ④ GRAB BAR (36" LONG)
- ⑤ TOWEL DISPENSER
- ⑥ TOILET TISSUE HOLDER
- ⑦ 18" x 36" MIRROR
- ⑧ SOAP DISPENSER
- ⑨ LIGHT FIXTURE
- ⑩ ONE PIECE SHOWER UNIT
- ⑪ UTILITY SINK (W/FAUCET)


- MODEL 812
- MODEL 812
- MODEL 250-15
- MODEL 508
- MODEL 780-1836
- MODEL 655
- LITHONIA 11890RE
- GELCOATED FIBERGLASS

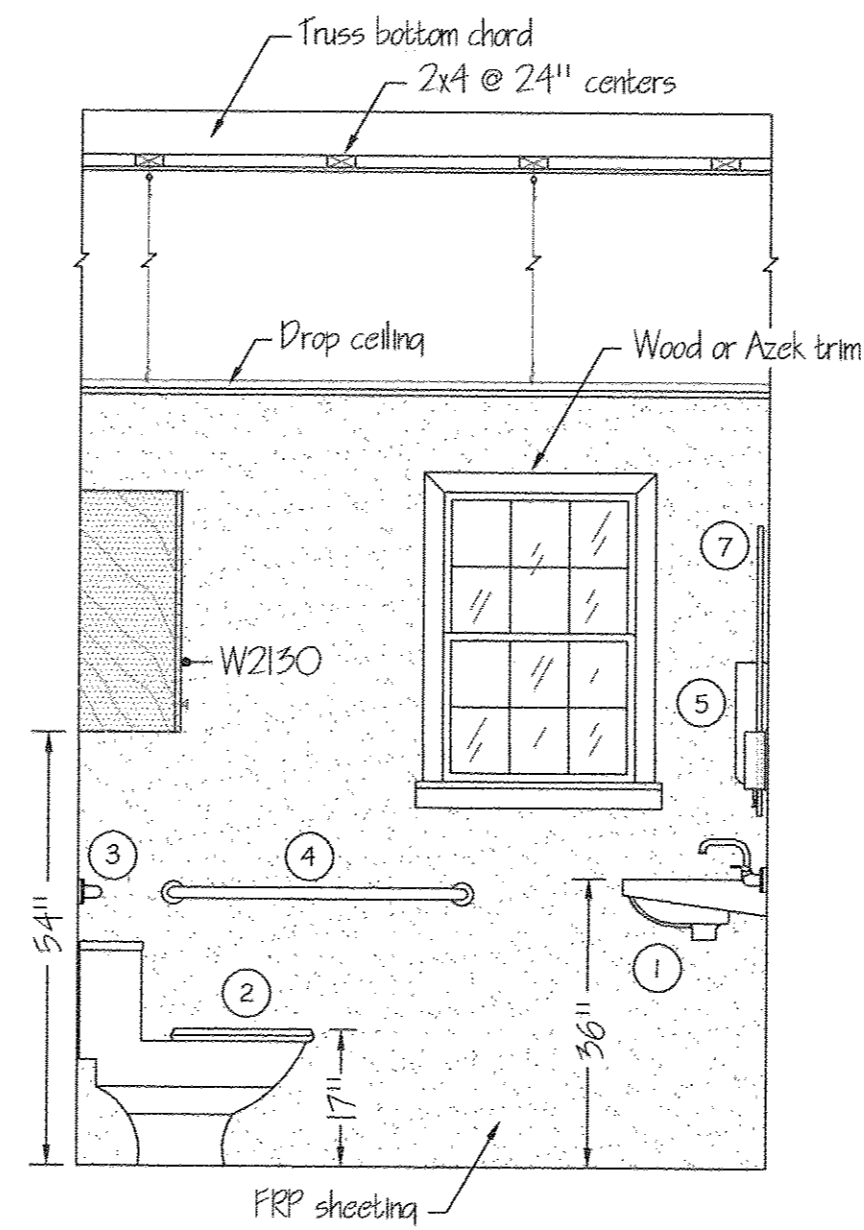


RESTROOM ELEVATIONS
SCALE: 1/2" = 1'-0"

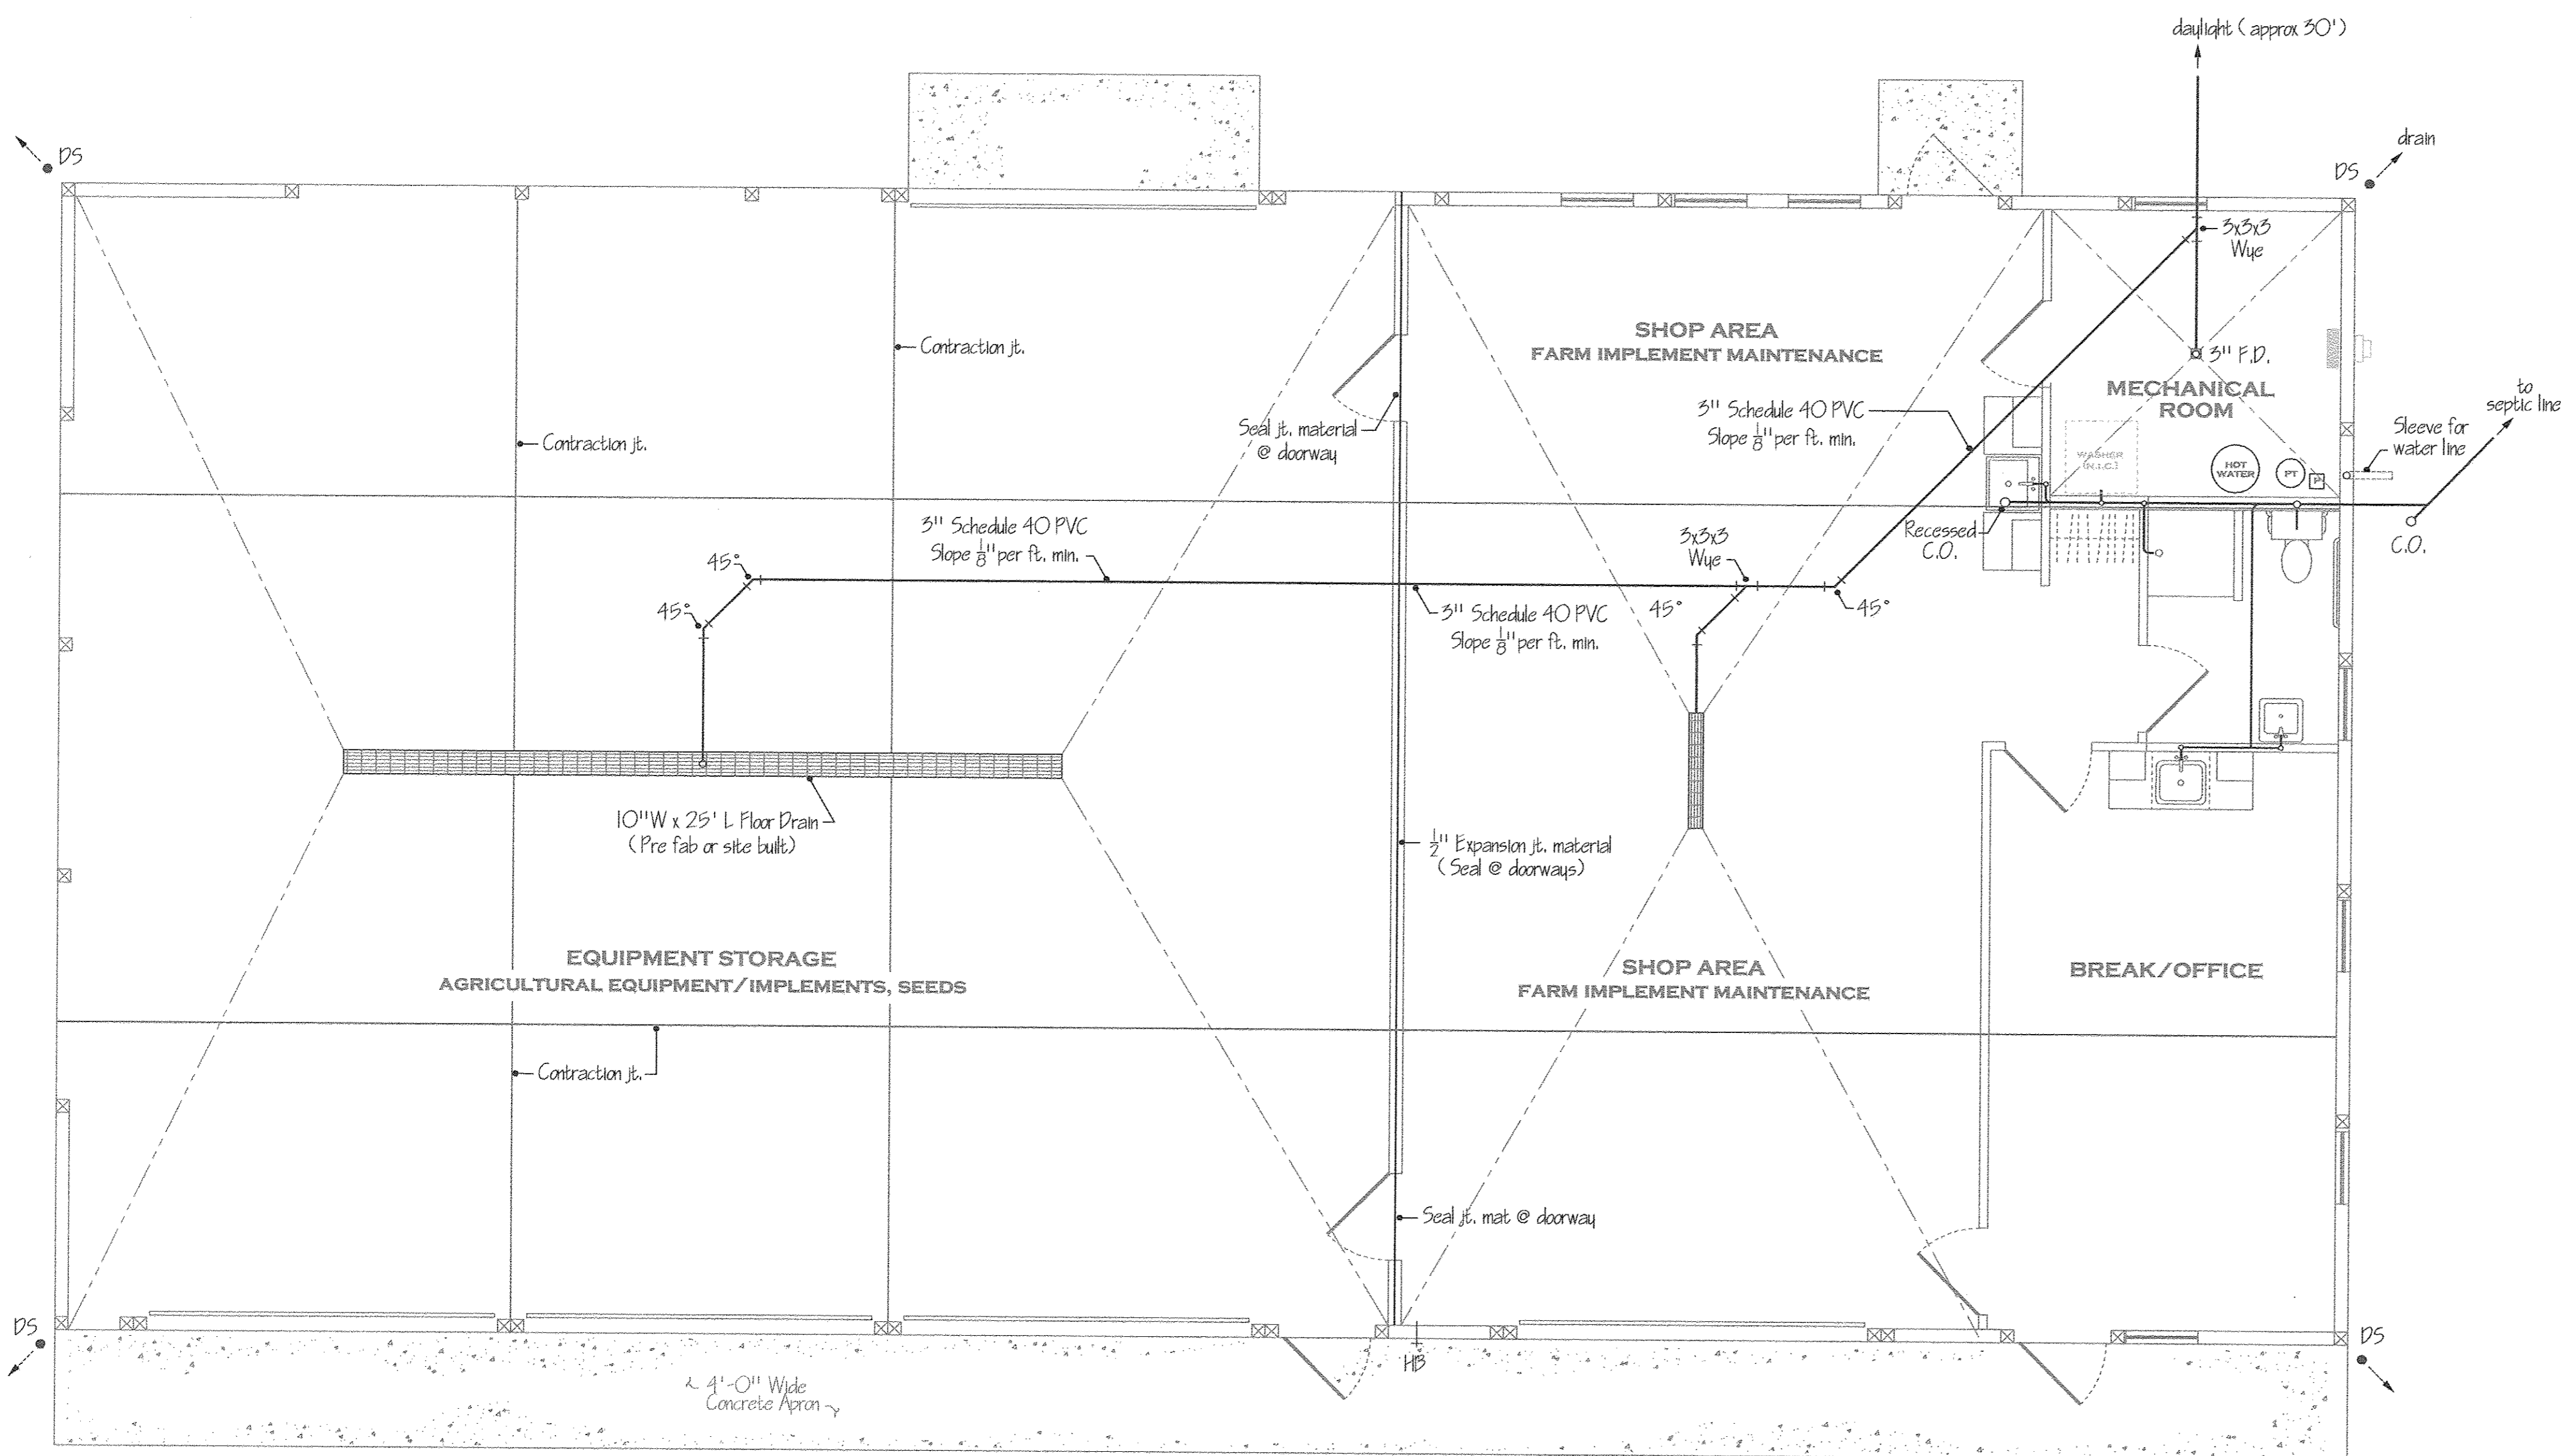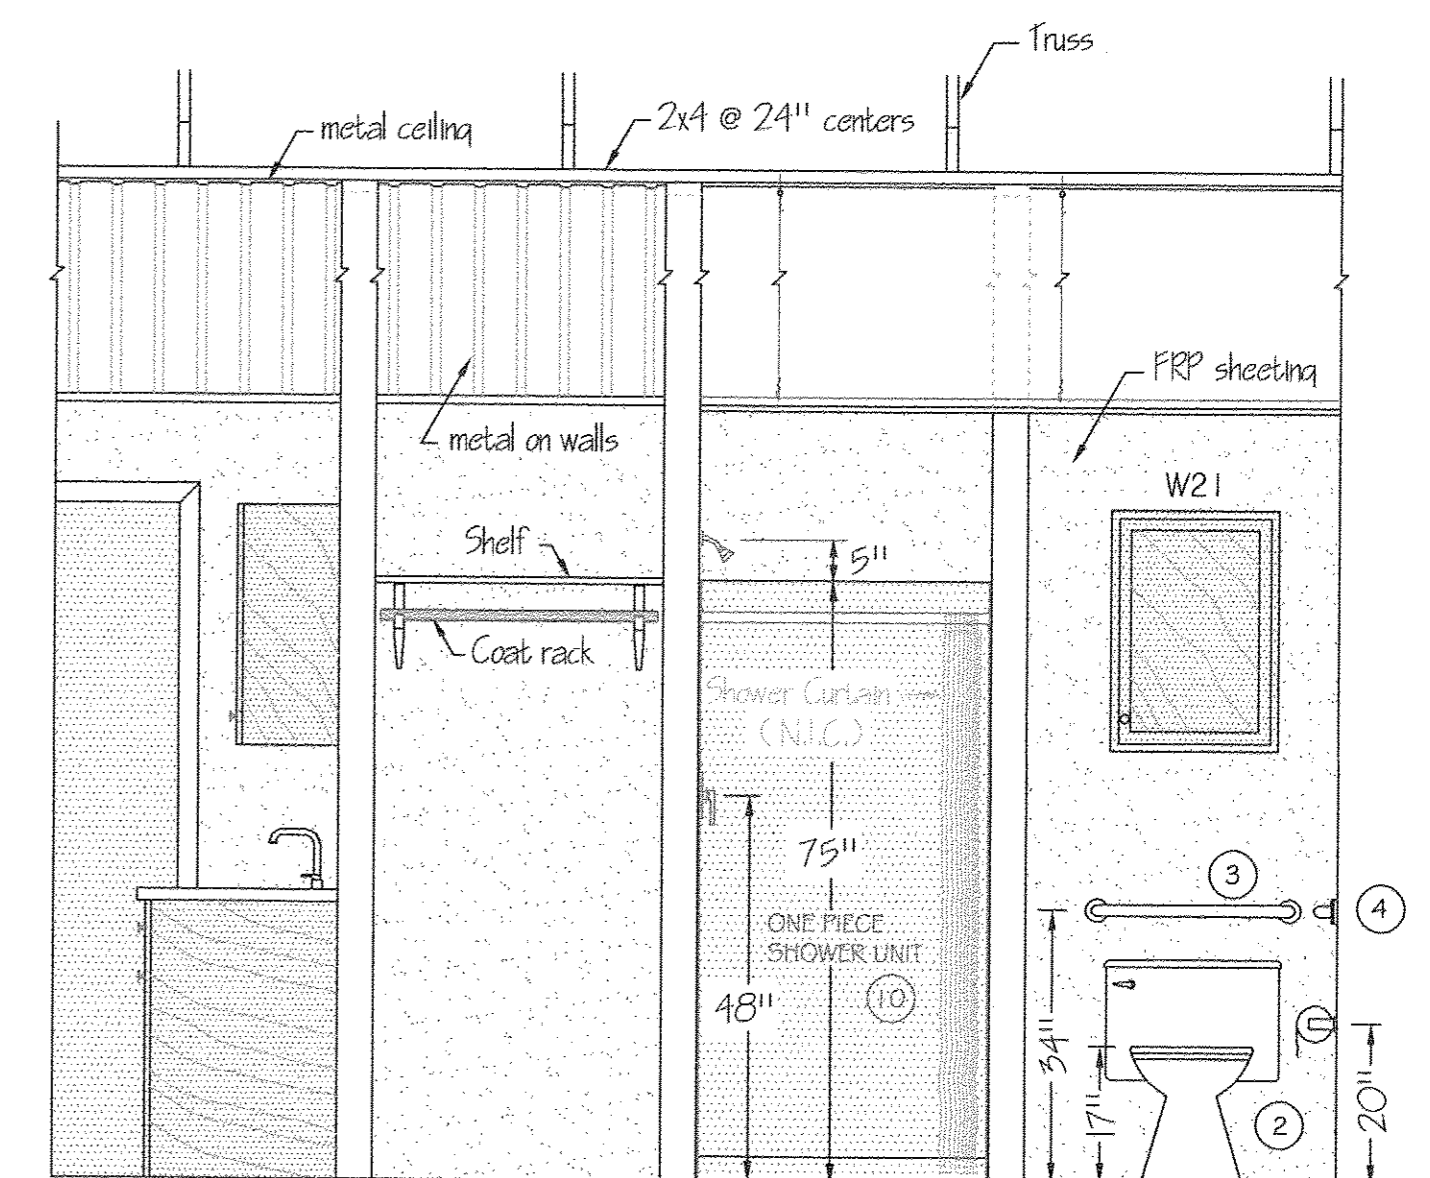


PLUMBING PLAN
SCALE: 1/4" = 1'-0"

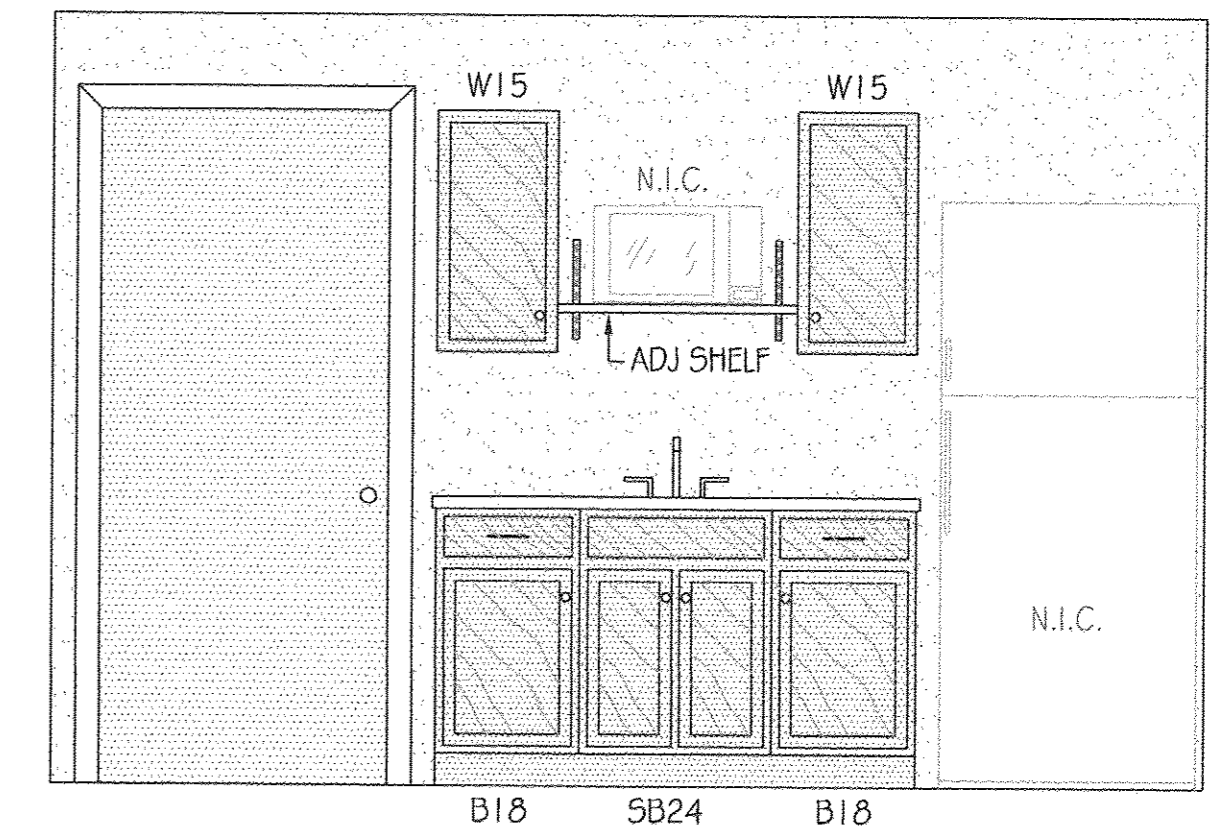

BREAK/OFFICE
SCALE: 1/2" = 1'-0"

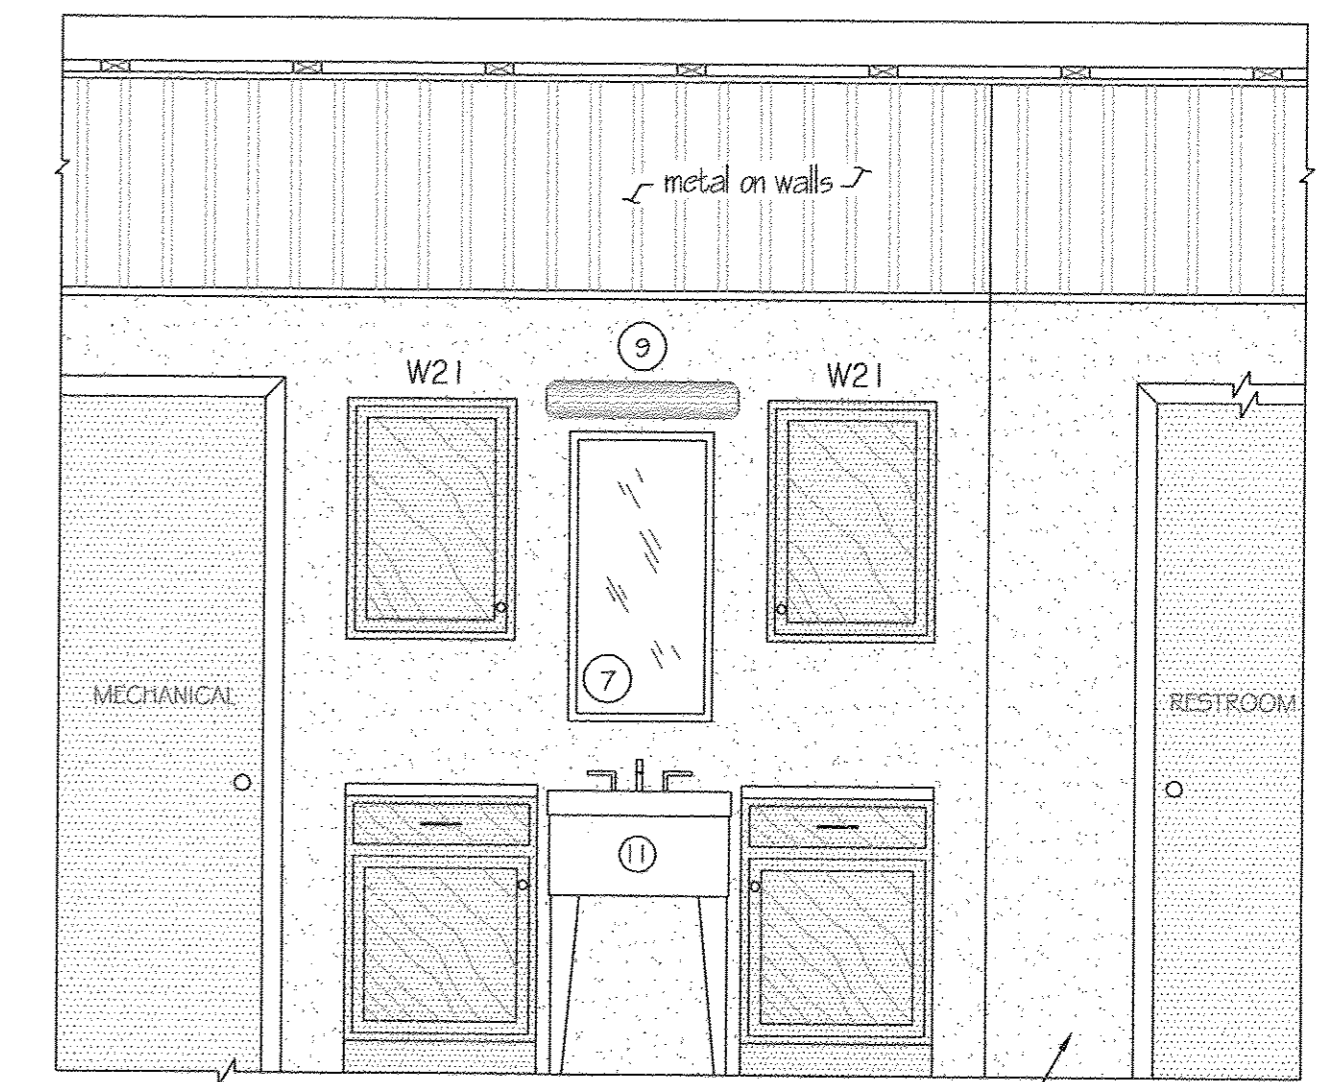

UTILITY AREA
SCALE: 1/2" = 1'-0"

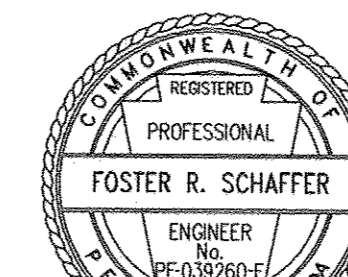

Foster R. Schaffer
8/17/18

PENNSYLVANIA GAME COMMISSION

STATE GAME LANDS # 245 EAST FINLEY TWP. WASHINGTON CO.
PLUMBING AND BATHROOM DETAILS

REVISIONS		PROJECT NO.	PCC-245-18-2
△		DRAWING NO.	245 PLUMBING-4
△		DRAWN BY:	JBM
△		DATE:	08-08-18
△		SHEET NO.	4 OF 5