


PLAN VIEW
SCALE: 1/4" = 1'-0"

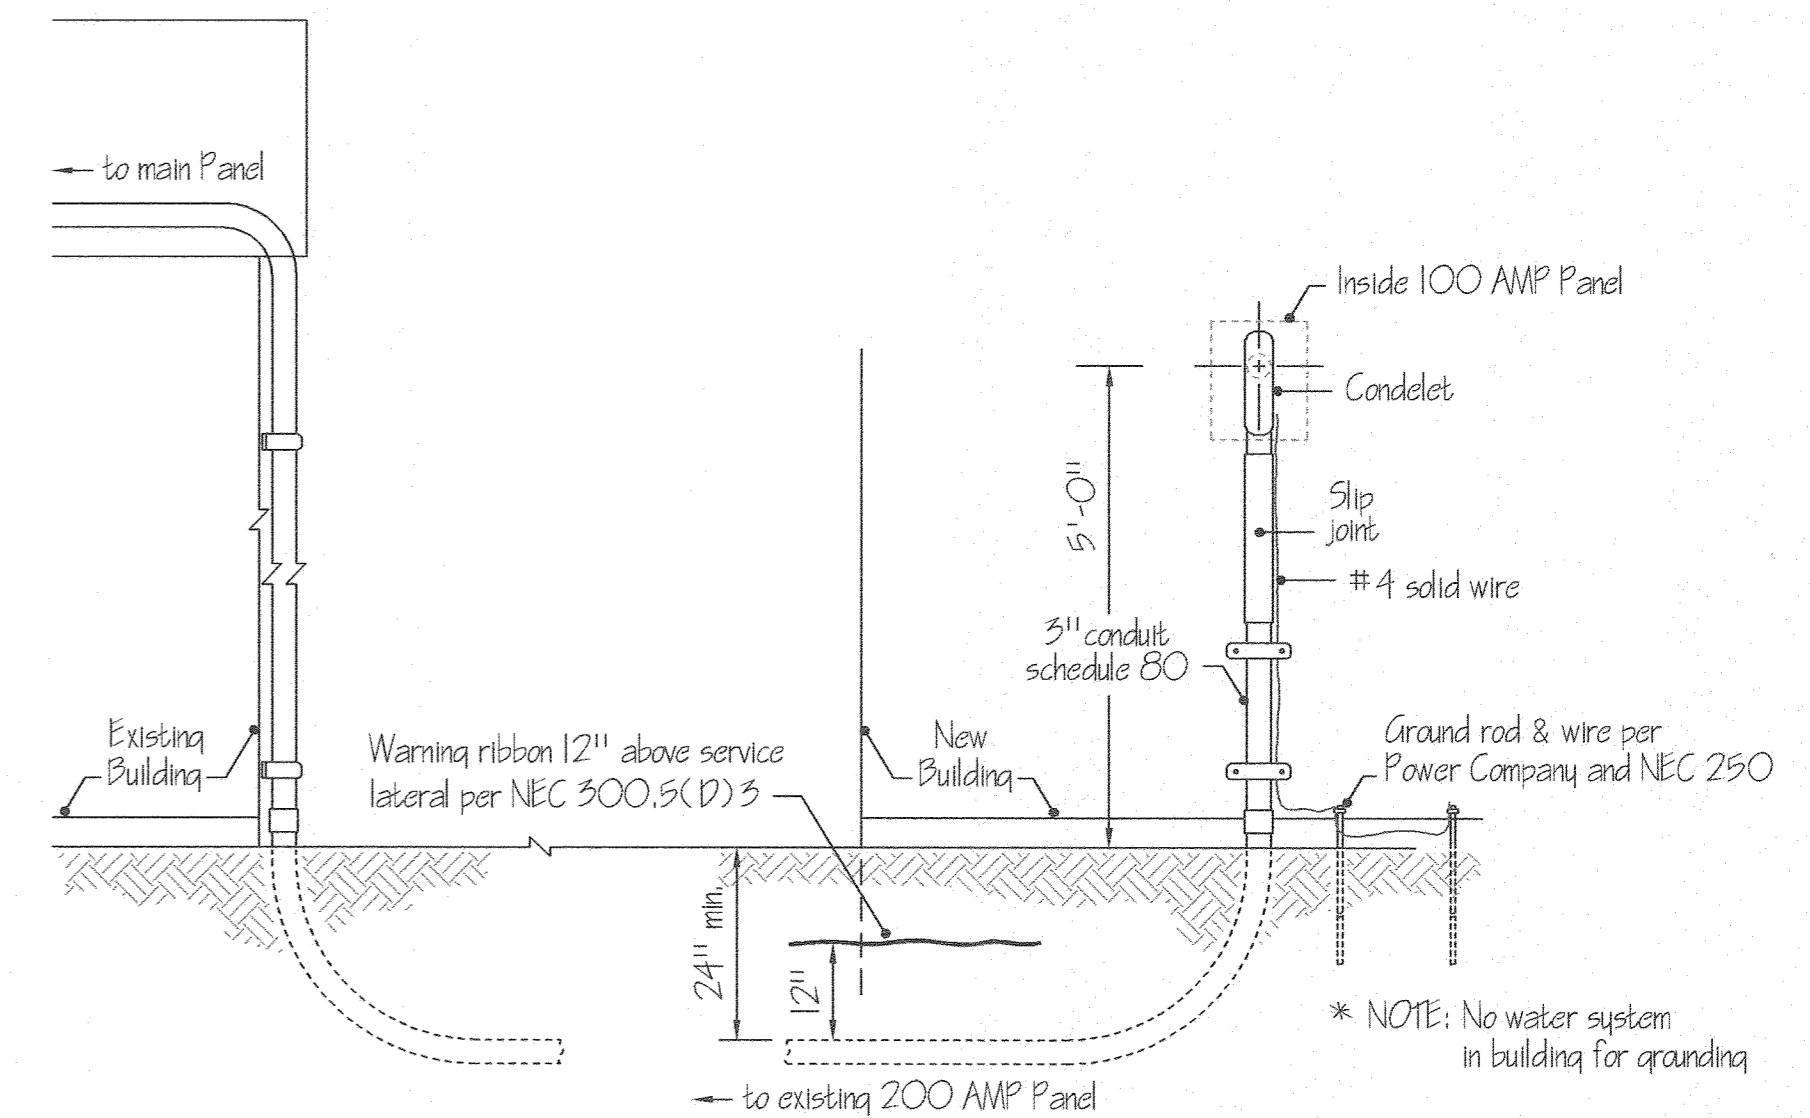

SERVICE DETAIL
NOT TO SCALE

ELECTRICAL WIRING SYMBOLS

- ⊕ GFI Receptacle
- ⊕ Duplex Outlet
- Home Run / Circuit #
- ⊙ Photo Cell
- ⊕ Exit lighting w/ batteries
- ⊕ Switch
- ⊕ Switch, 3 Way


MARK	QTY	LIGHTING SCHEDULE	MODEL
A	0	16.75" x 4" Surface Mount, 4 Lamp Elec Ballast, 15	LITHONIA SB432MVOLTGEPI015
B	0	2" x 4" LED Panel	SINKAR LDP2450L40U1
C	10	15.25" x 22" 4 LAMP LED HIGH BAY	LITHONIA 1B15000LM SP080 MD OZIO 40K 80 CRI
D	0	2" Fluorescent wall mount	LITHONIA 11890RE
E	2	Security motion, Wall Mount / Outside Unit	HEATH ZENITH SL-5630-BZ
F	2	Exit & Emergency combo light w/ batteries & remote head	LITHONIA ECRLEDPHO M6 w/ ELA LED WP M12

* Quotes for lighting fixtures can be provided by Gene Grassed of Dauphin Electric • 717-986-9558.


LOAD CENTER
VOLTAGE: 240/120V
SERVICE FEEDER: SE Aluminum 2,2,2,4 rated 600 volts THHN/ THWN @ 90°C

All exposed wiring must be MC or in conduit


Circuit No.	Circuit Breakers Poles	Amps	100 AMP Main Service Breaker	Wiring No./ Size
1	1	20	Lighting all bays	3 - #12
2	1	20	Receptacles 1st three bays	3 - #12
3	1	20	Storage Receptacles last two bays	3 - #12
4	1	20	Emergency Lighting	3 - #12
5	1	20	Spare Breaker	
6-8			Spare Spaces	

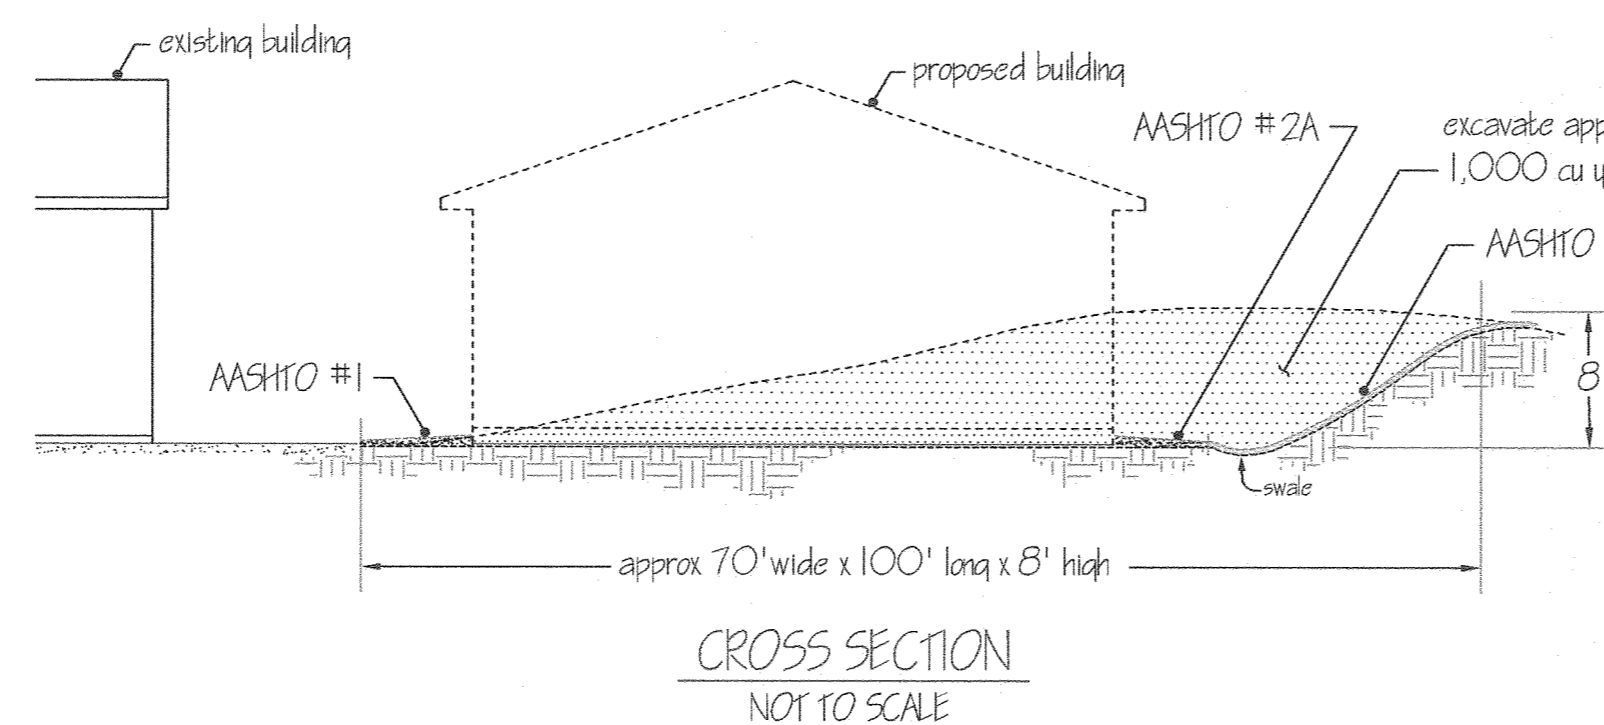

CROSS SECTION
NOT TO SCALE

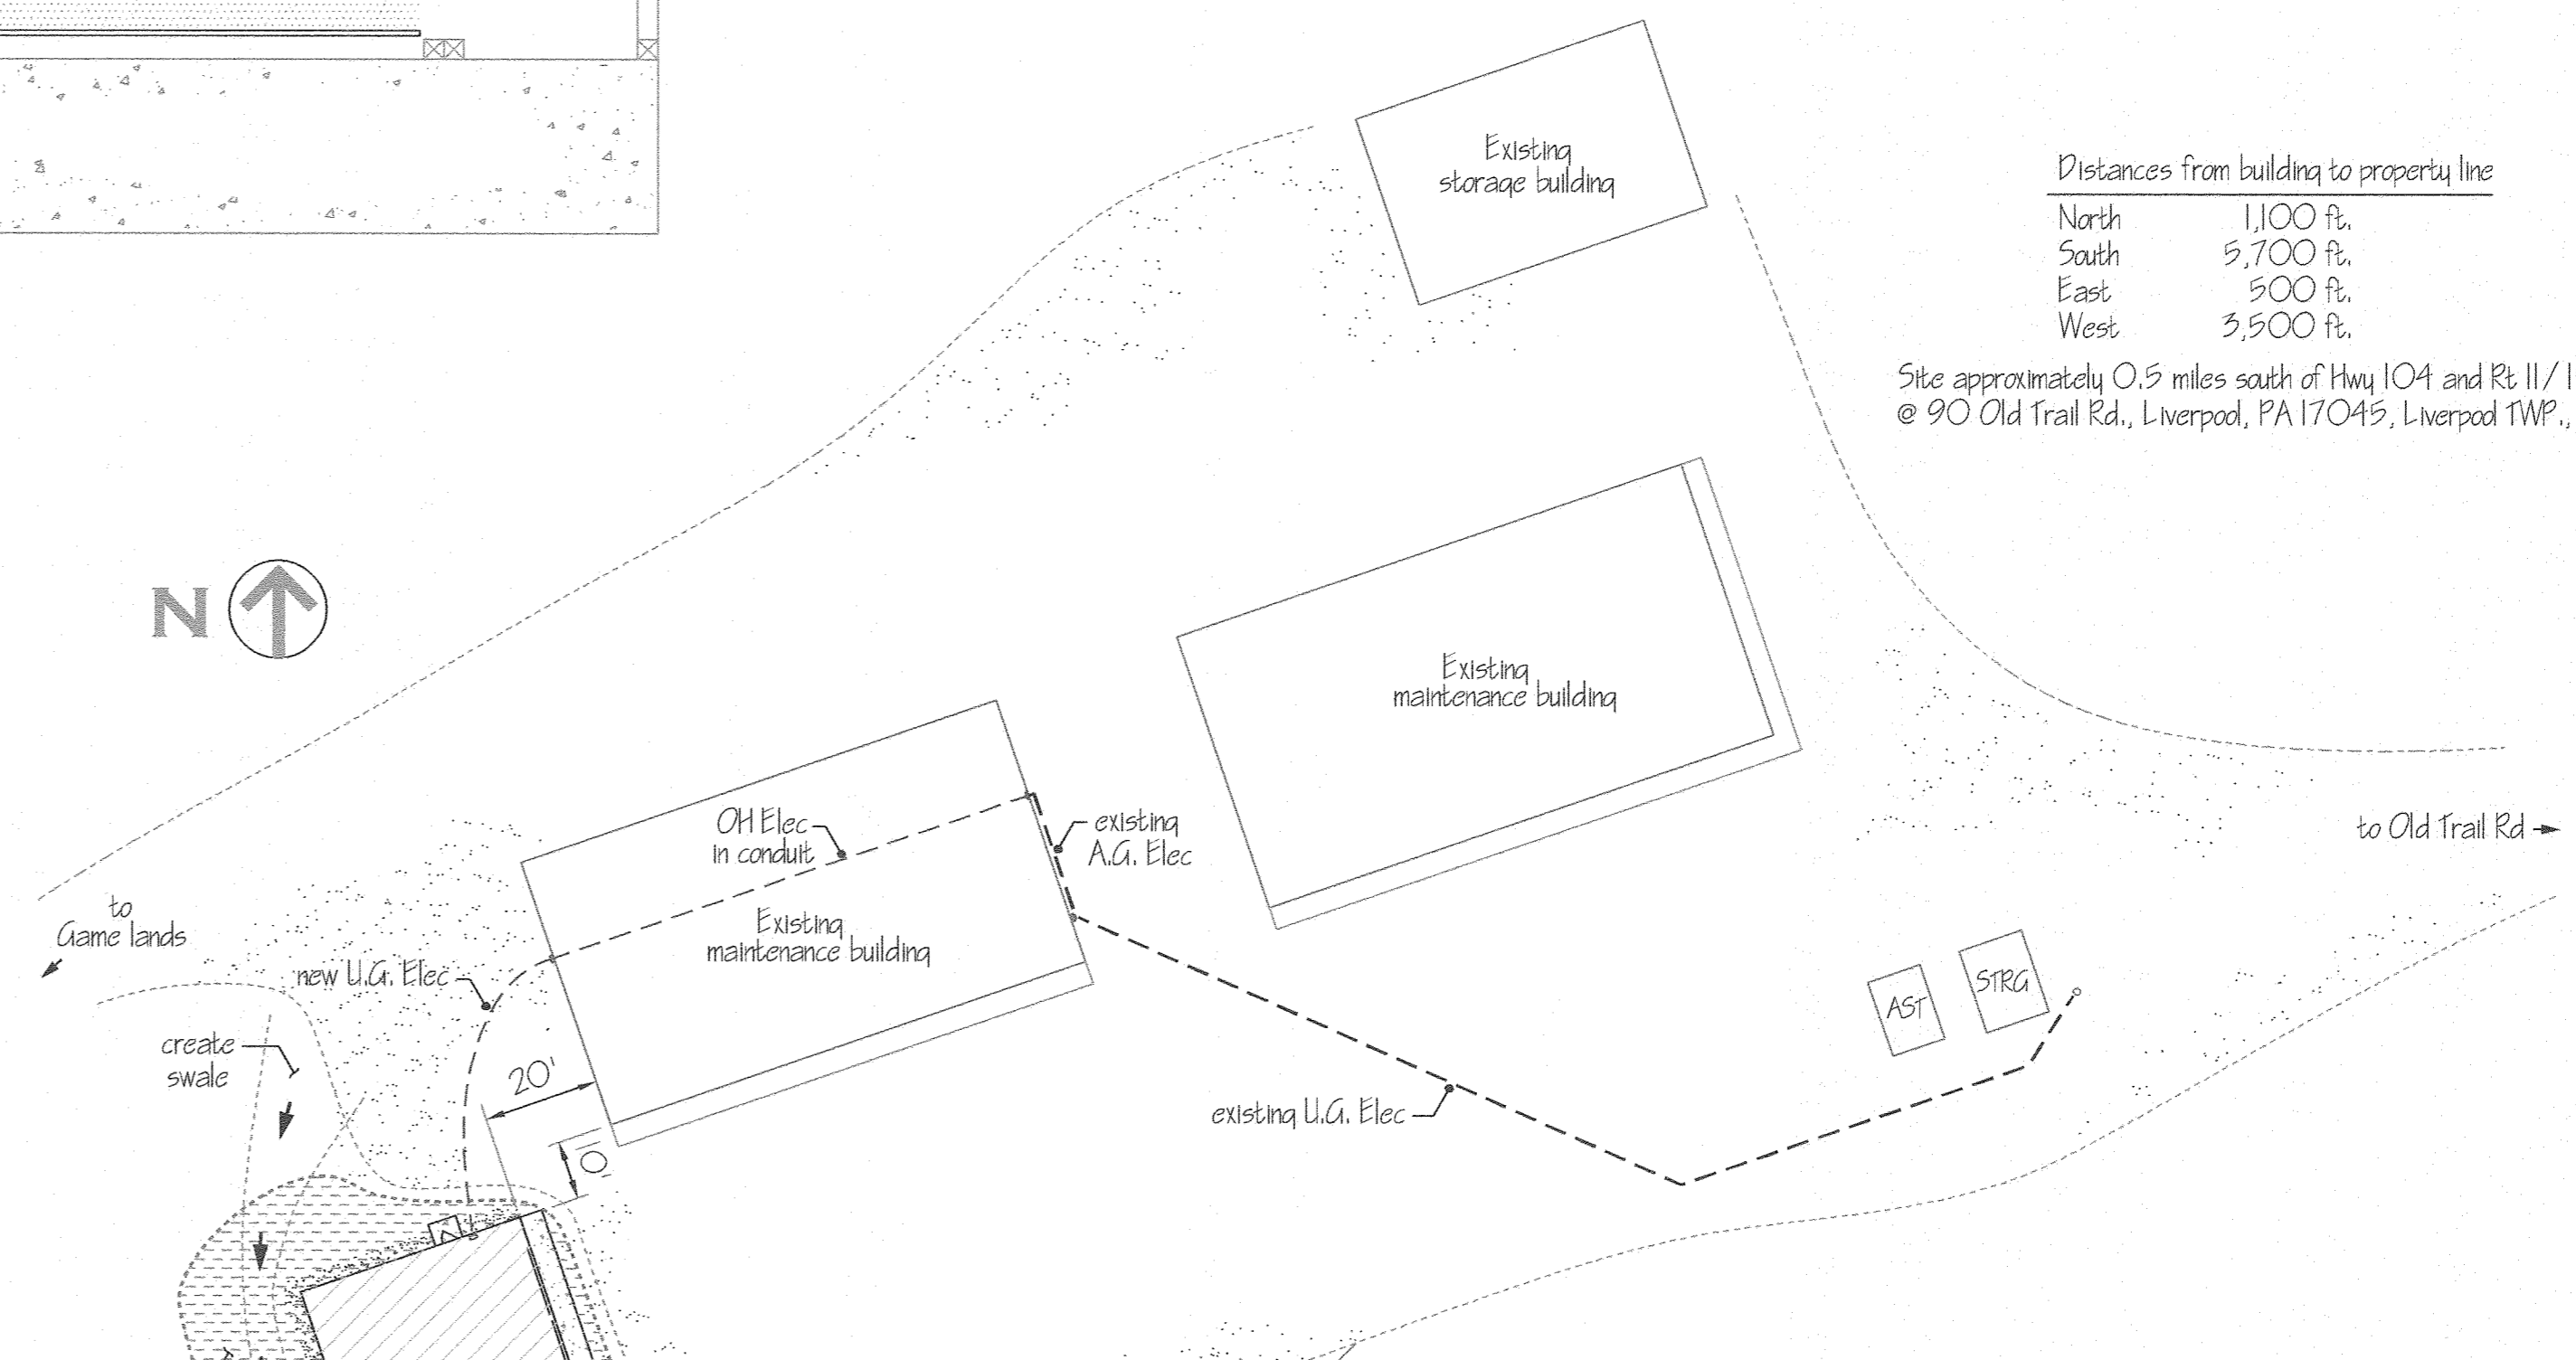

SITE PLAN
1" = 30'

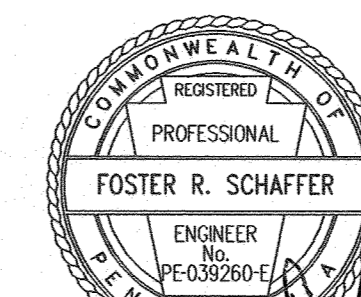

Foster R. Schaffer
1/1/19

PENNSYLVANIA GAME COMMISSION

STATE GAME LANDS NO. 258 | LIVERPOOL TWP | PERRY COUNTY

ELECTRICAL PLAN AND SITE PLAN

REVISIONS	PROJECT NO.	PGC-258-18-1
▲	DRAWING NO.	258-3
▲	DRAWN BY:	JBM
▲	DATE:	02/23/19
▲	SHEET NO.	3 OF 3