



WATER SUPPLY ISOMETRIC
NO SCALE


- BRADLEY CORP. (FOR REF. ONLY)
FIXTURE/ACCESSORY LEGEND
- ① SINK (W/FAUCET)
 - ② FLOOR MOUNTED WATER CLOSET
 - ③ GRAB BAR (24" LONG)
 - ④ GRAB BAR (36" LONG)
 - ⑤ TOWEL DISPENSER
 - ⑥ TOILET TISSUE HOLDER
 - ⑦ 18" x 36" MIRROR
 - ⑧ SOAP DISPENSER
 - ⑨ LIGHT FIXTURE
 - ⑩ ONE PIECE SHOWER UNIT
 - ⑪ UTILITY SINK (W/FAUCET)
- MODEL 812
 - MODEL 812
 - MODEL 250-15
 - MODEL 508
 - MODEL 780-1836
 - MODEL 655
 - 2" INTEGRATED LED
 - GELCOATED FIBERGLASS
 - SEE SPECS

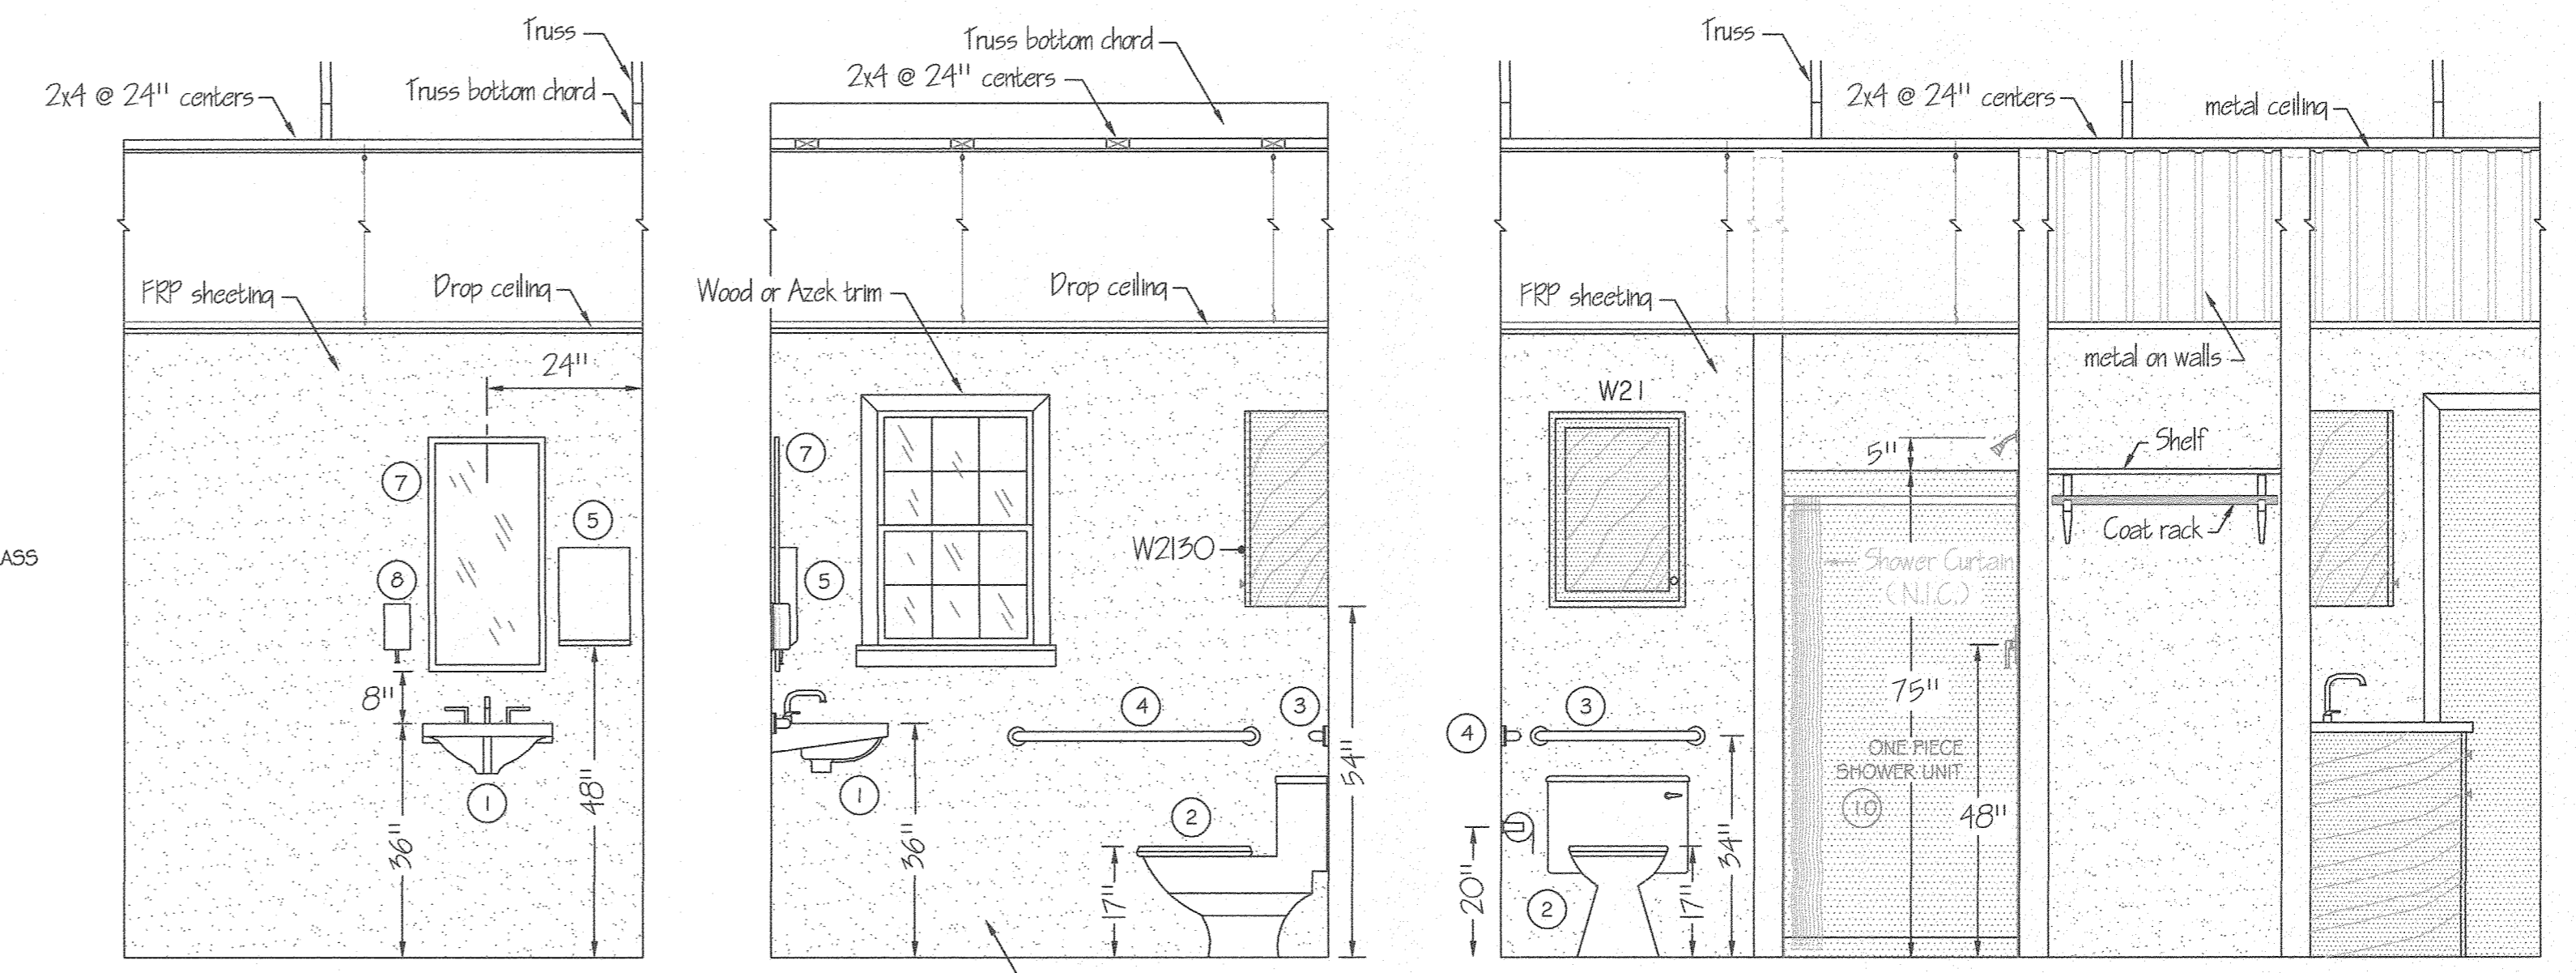


RESTROOM ELEVATIONS
SCALE: 1/2" = 1'-0"

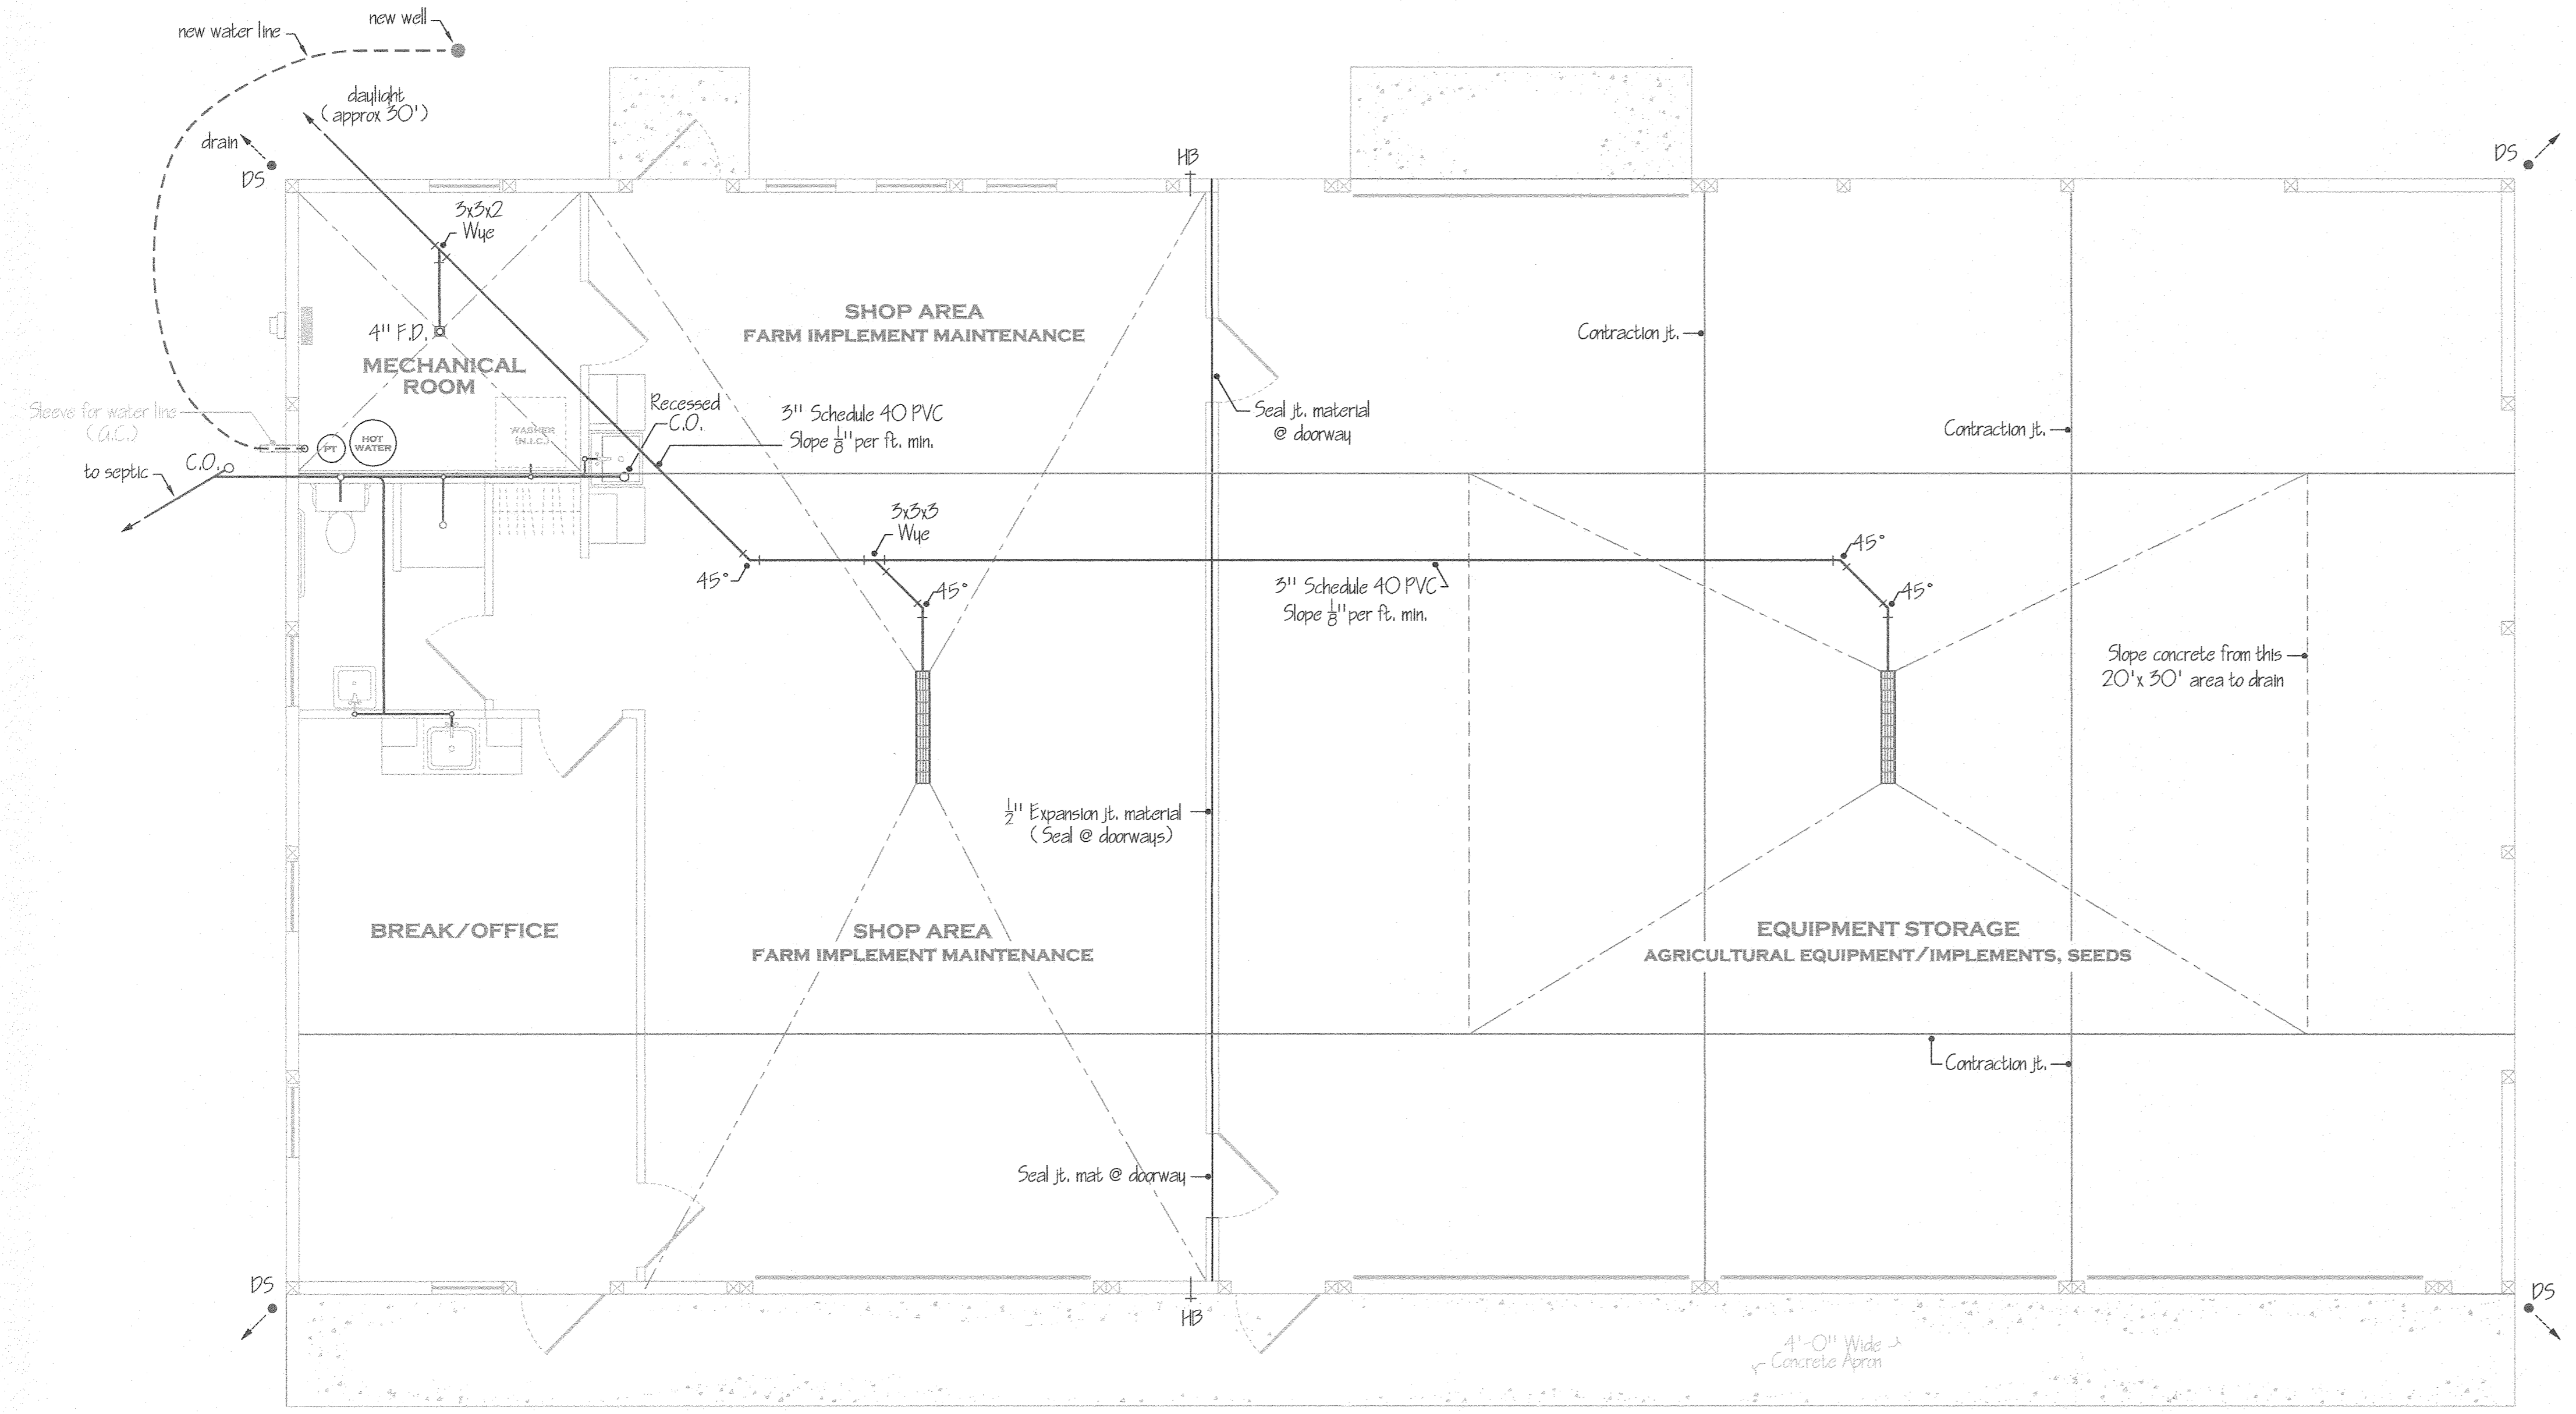


PLUMBING PLAN
SCALE: 1/4" = 1'-0"

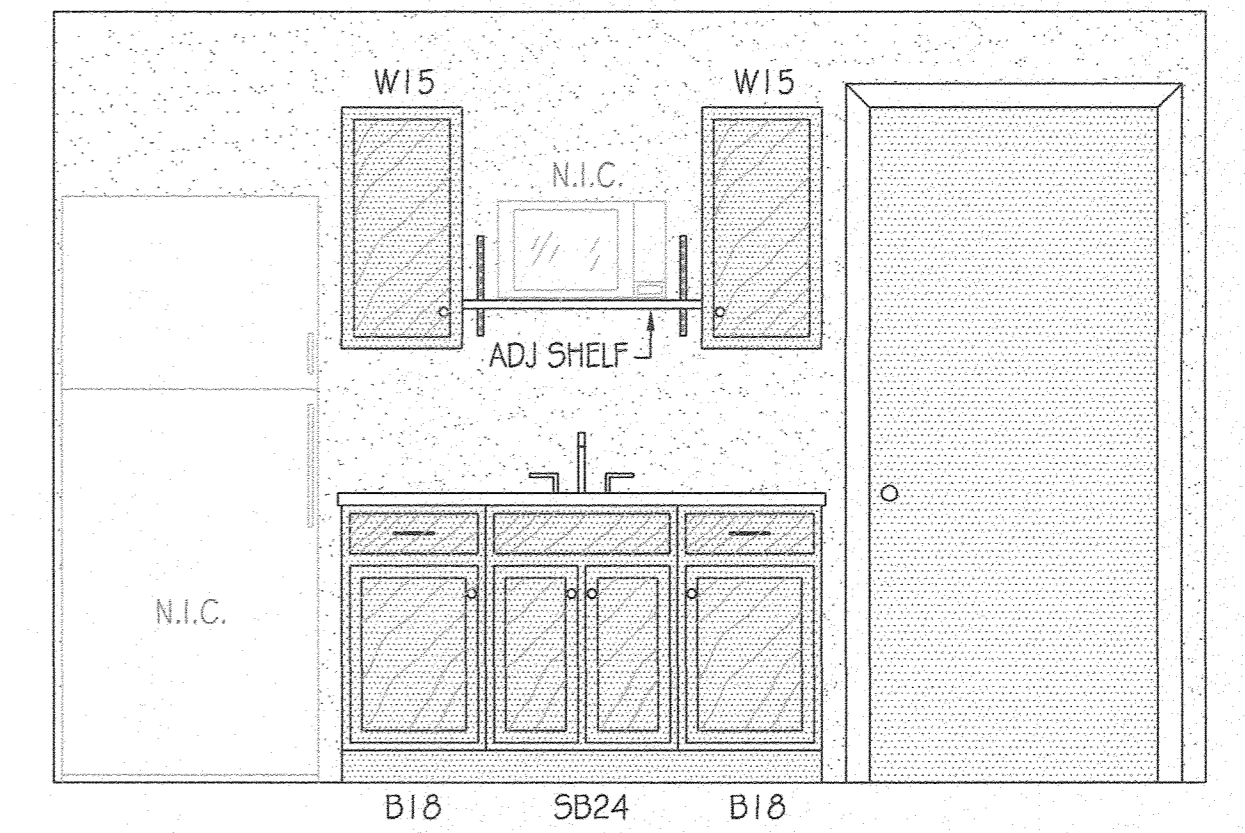

BREAK/OFFICE
SCALE: 1/2" = 1'-0"

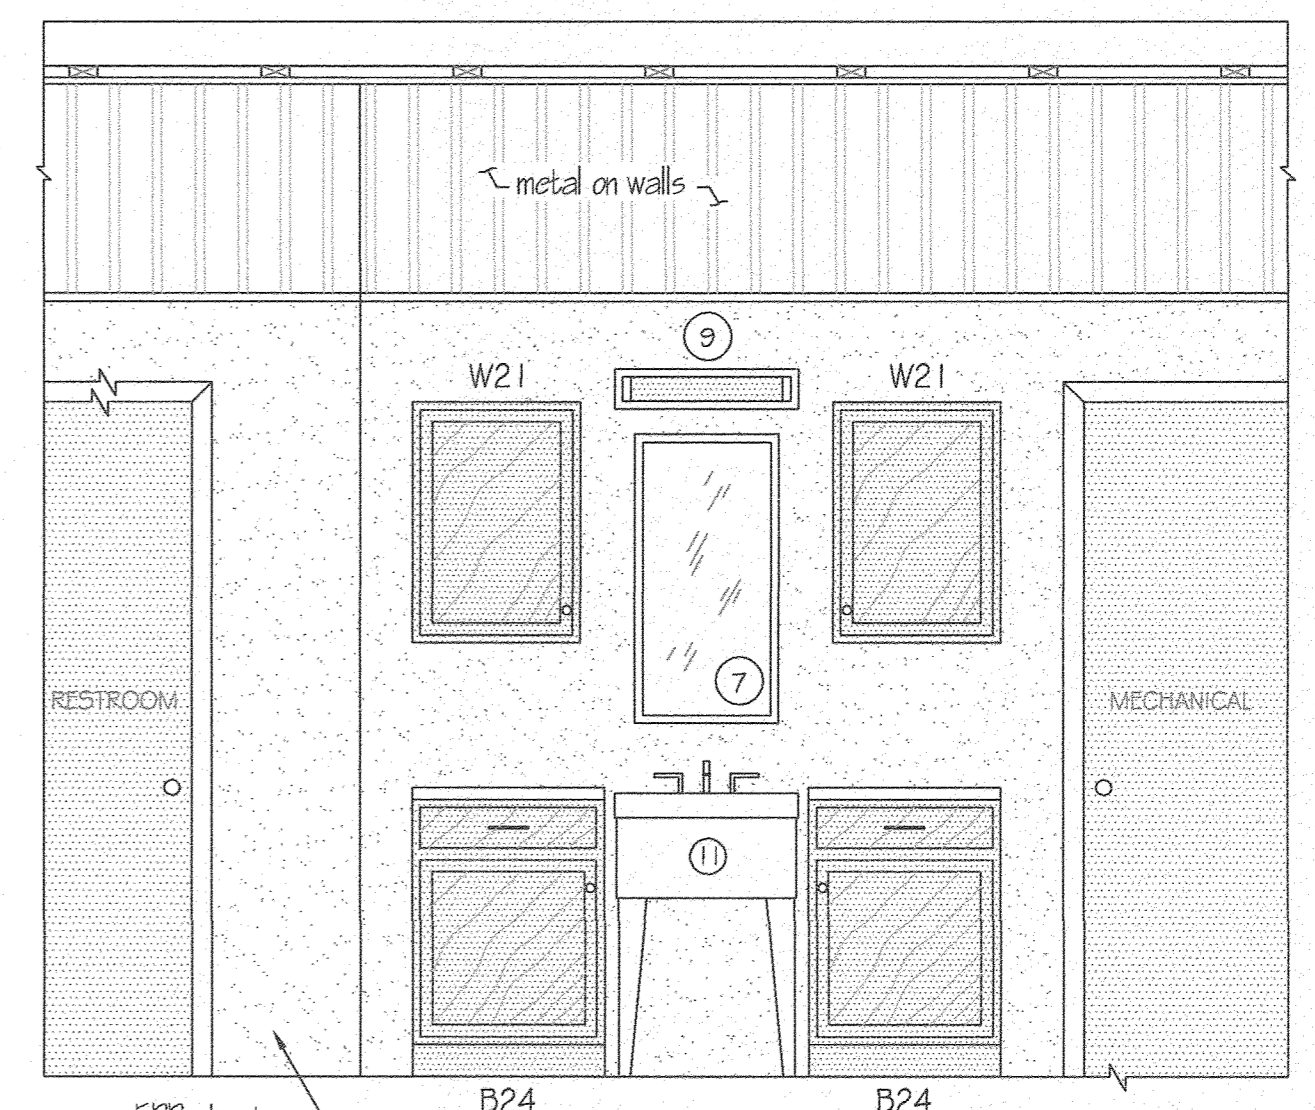

UTILITY AREA
SCALE: 1/2" = 1'-0"

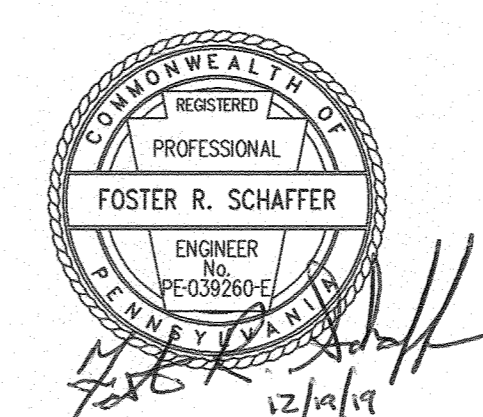

PENNSYLVANIA GAME COMMISSION		
STATE GAME LANDS #322	LOGAN TWP.	HUNTINGDON CO.
PLUMBING AND BATHROOM DETAILS		
REVISIONS		
△		
△		
△		
△		
△		
PROJECT NO.	PCC-322-19-1	
DRAWING NO.	322-PLUMBING-4	
DRAWN BY:	JBM	
DATE:	12-19-19	
SHEET NO.	4 OF 5	