



RIFLE RANGE SECTION

Scale: 1 in. = 6 ft.

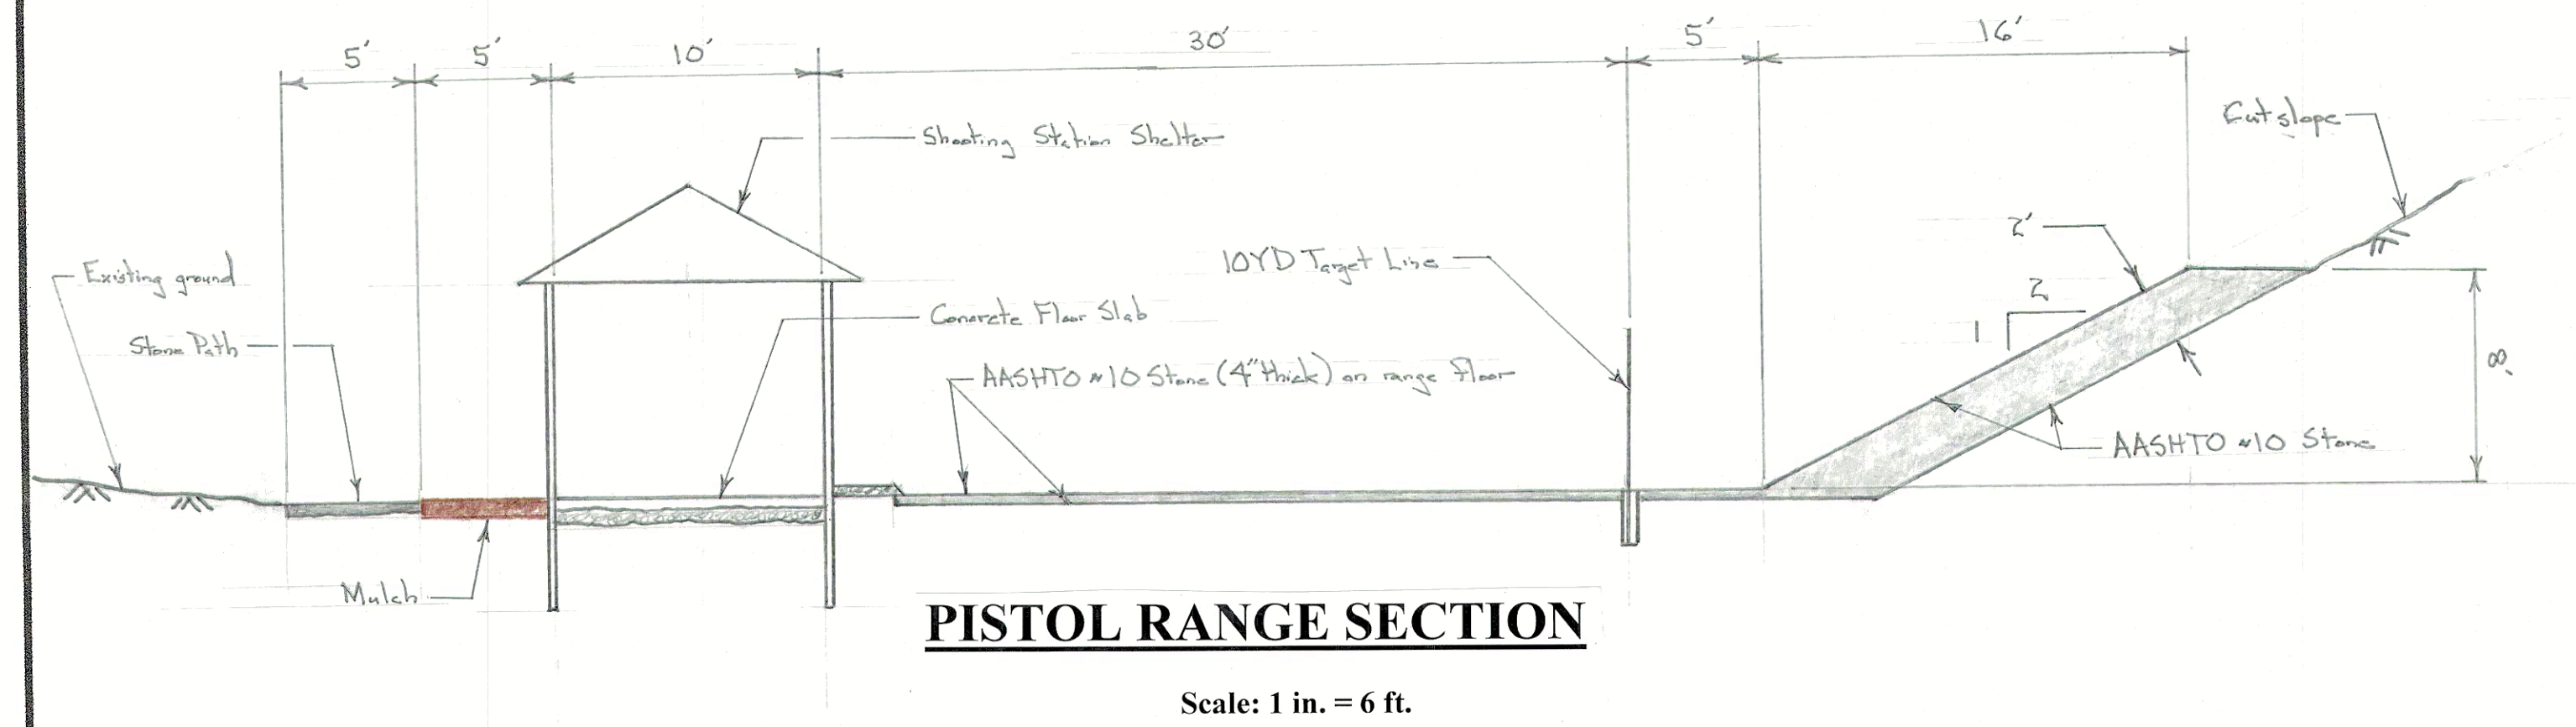


PISTOL RANGE SECTION

Scale: 1 in. = 6 ft.

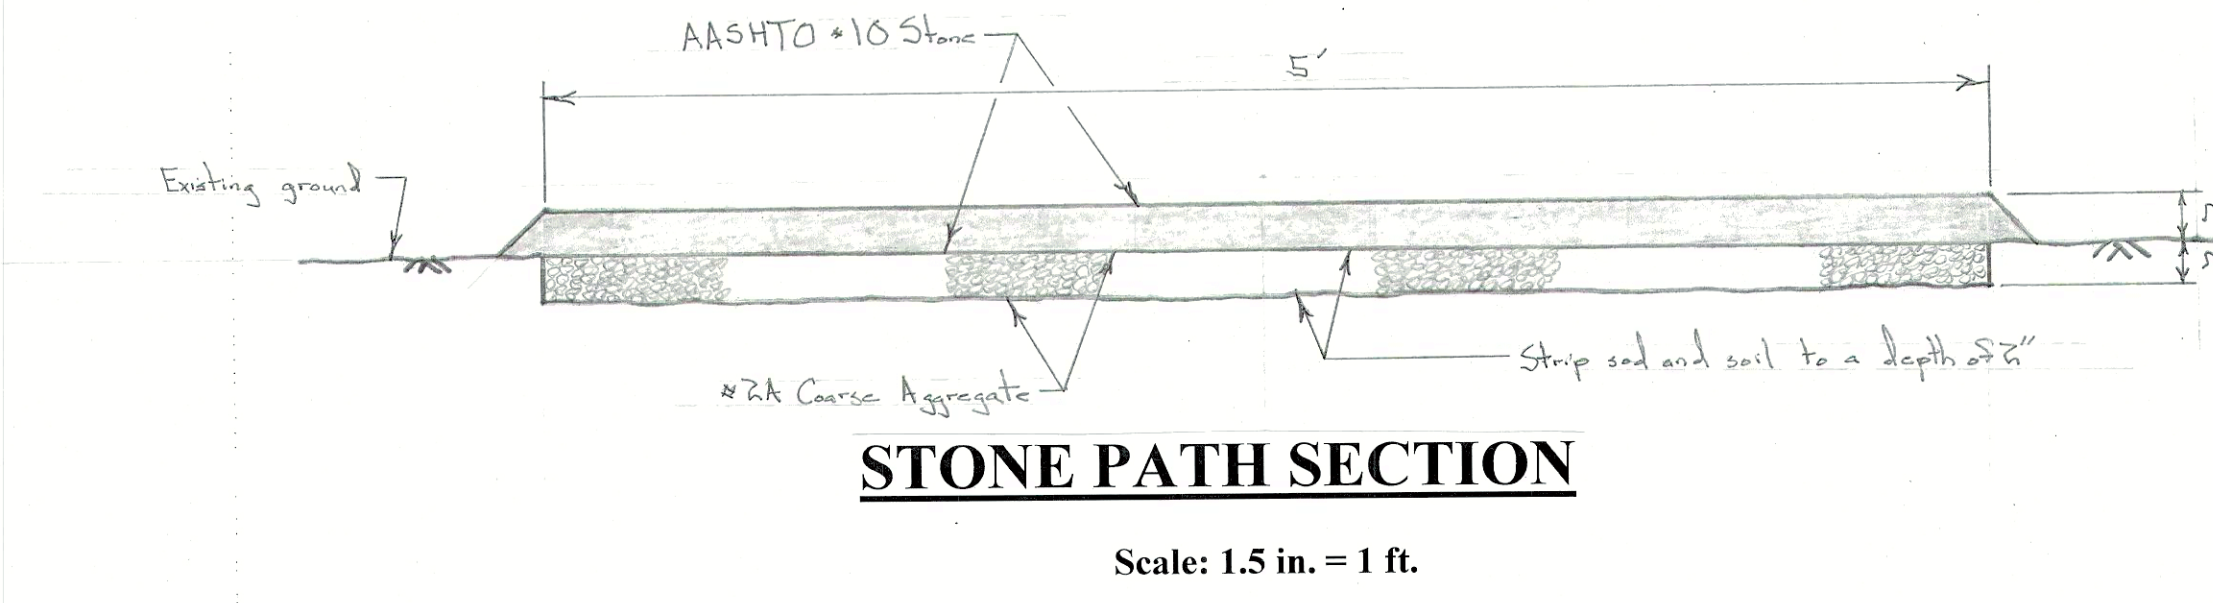


STONE PATH SECTION

Scale: 1.5 in. = 1 ft.

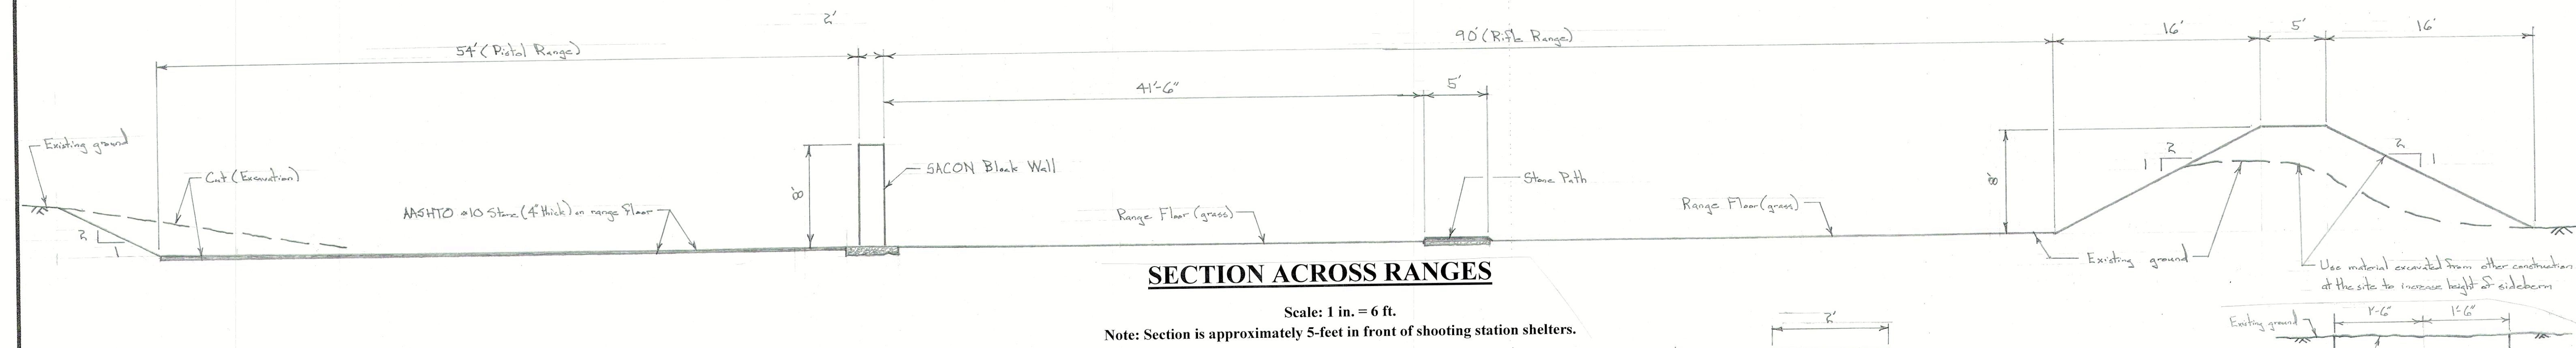


SECTION ACROSS RANGES

Scale: 1 in. = 6 ft.
Note: Section is approximately 5-feet in front of shooting station shelters.

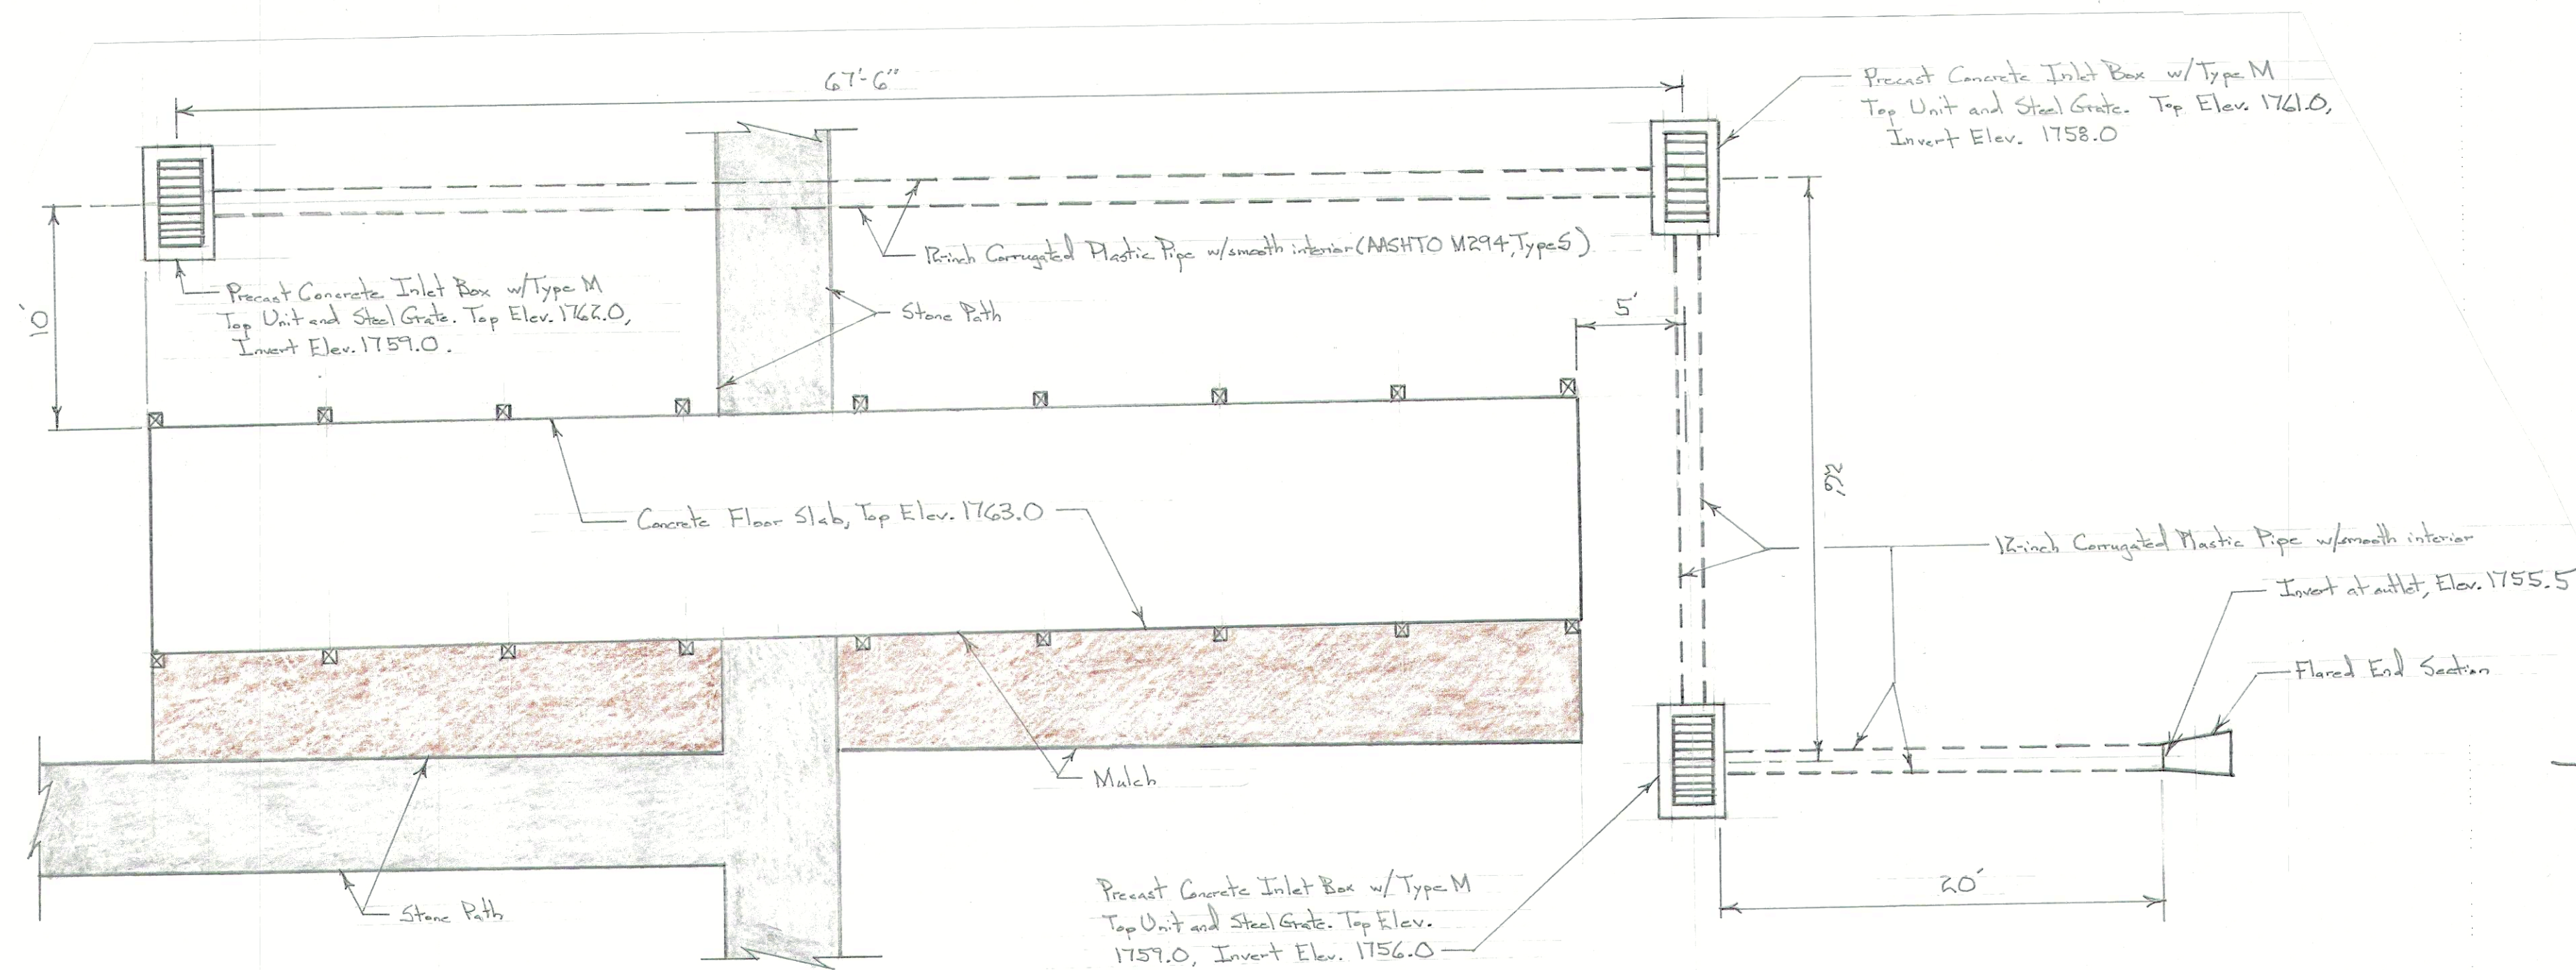


DRAINAGE PIPE PLAN

Scale: 1 in. = 6 ft.

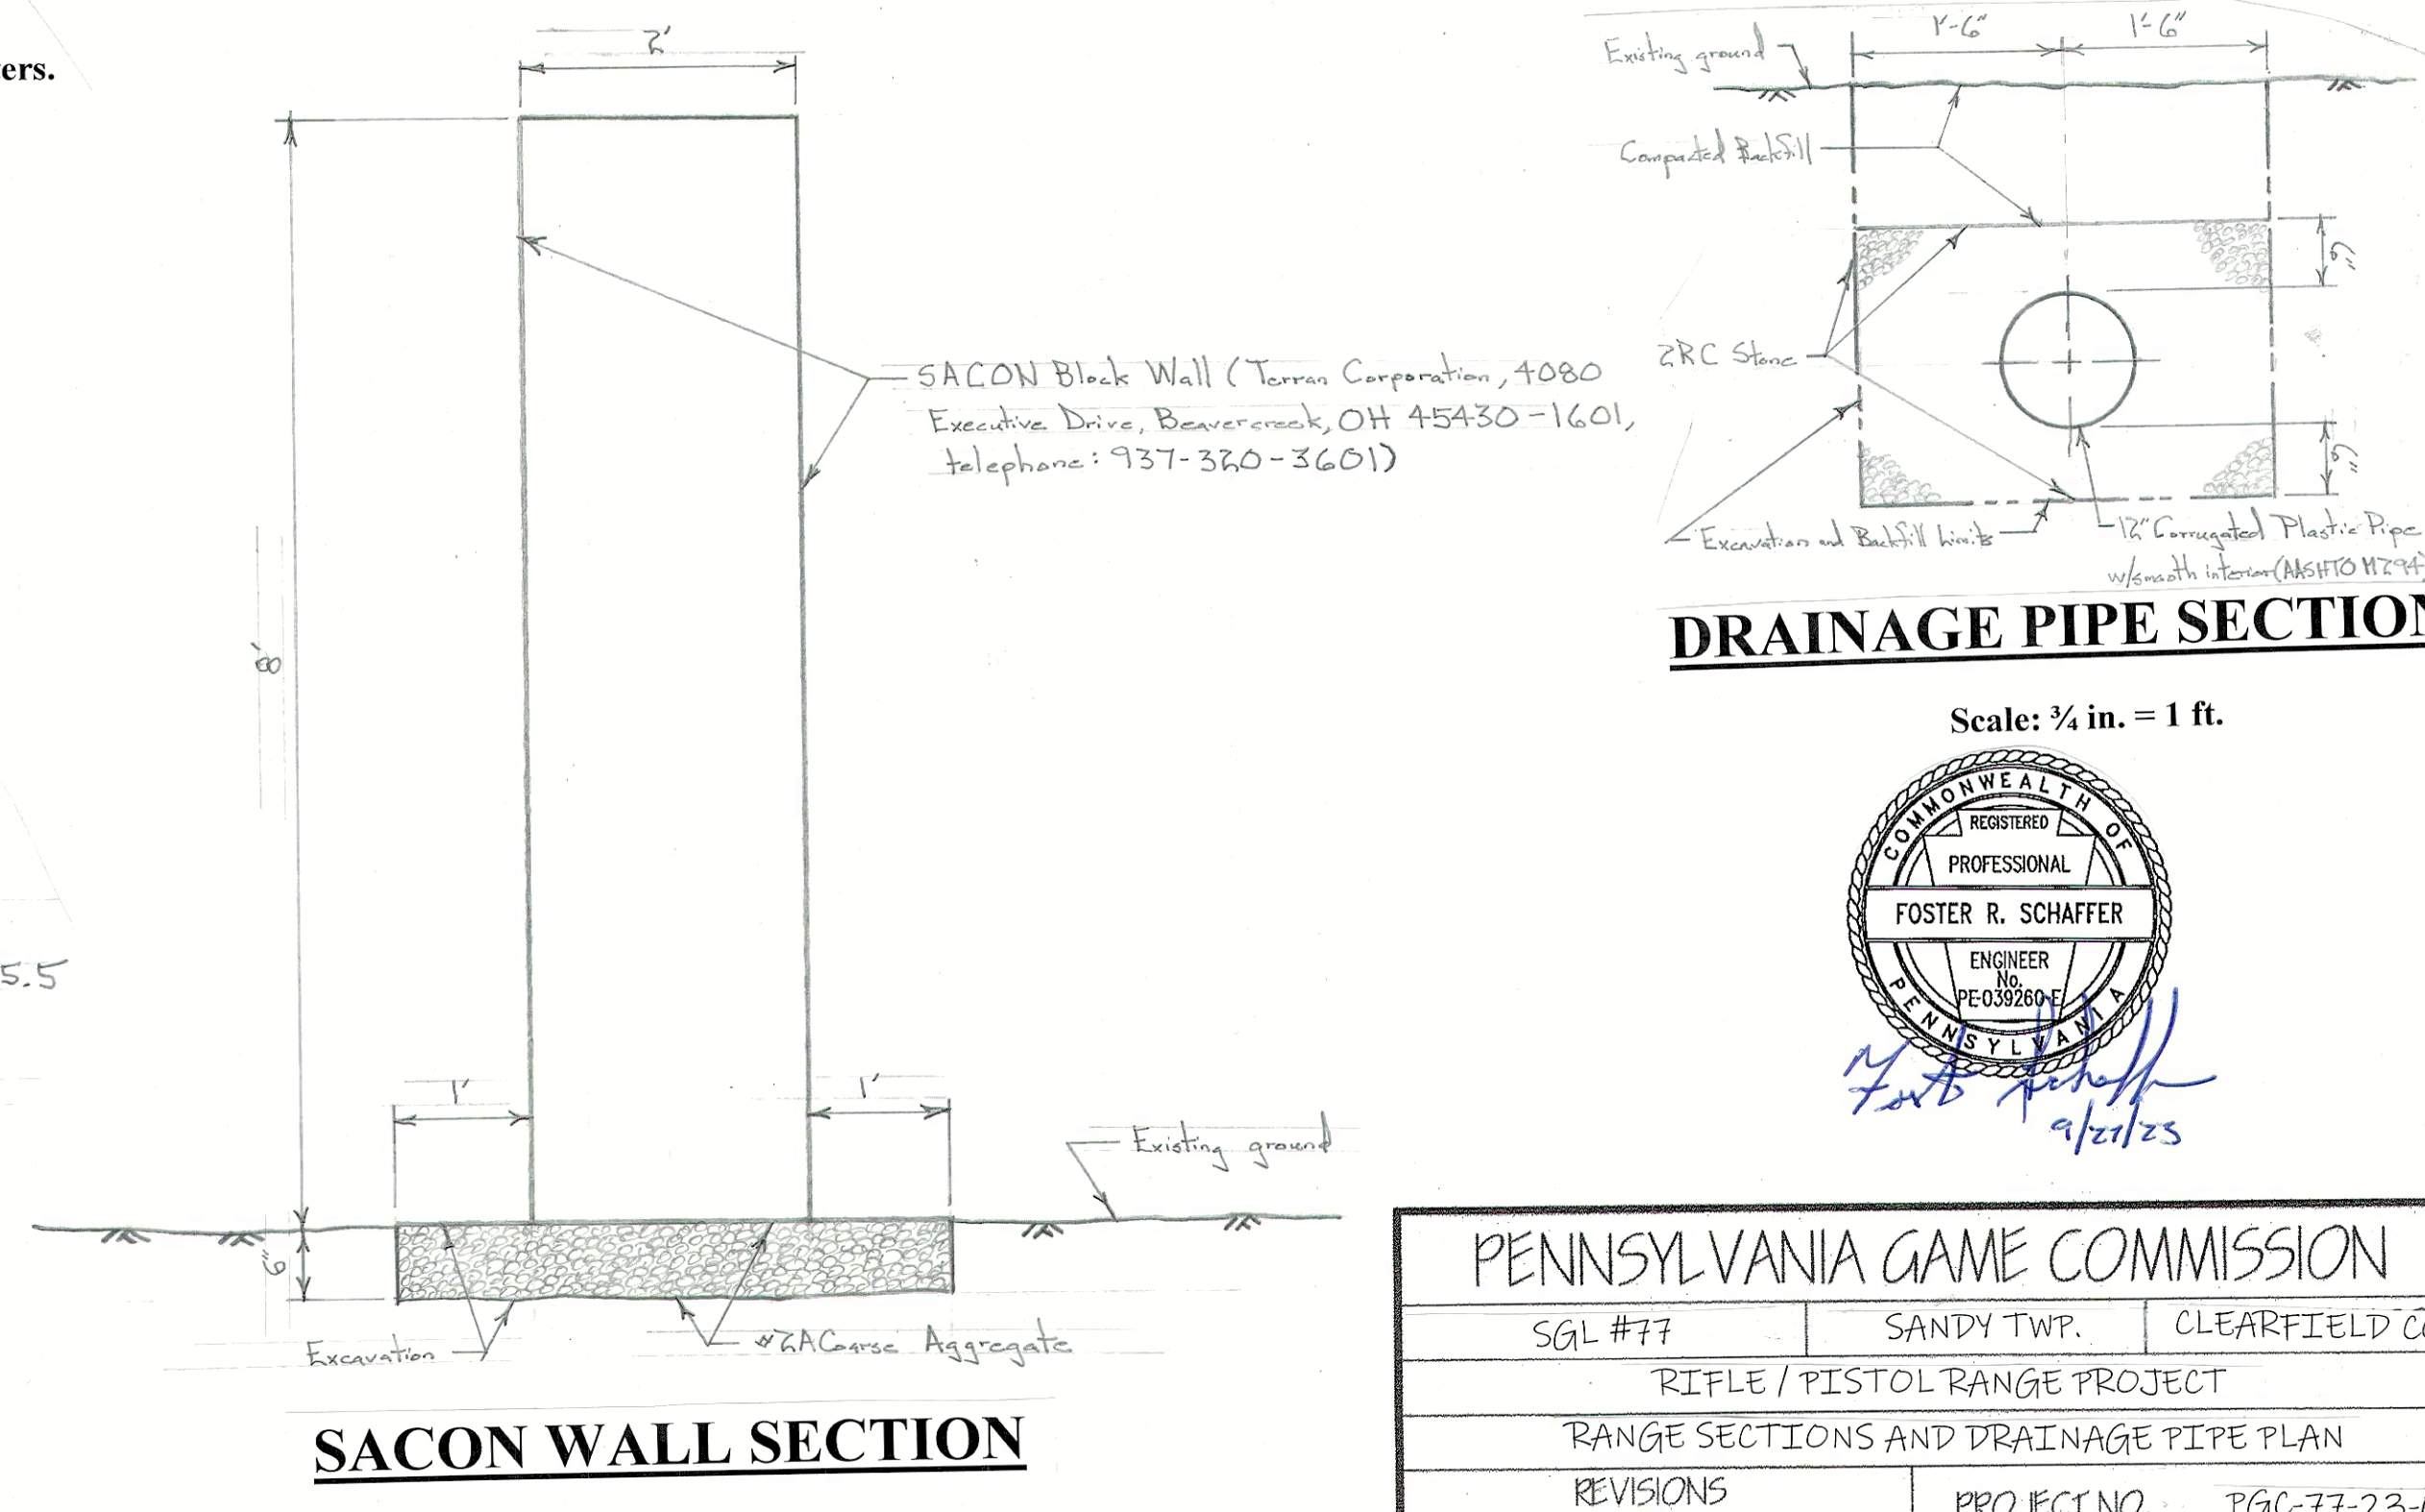


SACON WALL SECTION

Scale: 1/4 in. = 1 ft.

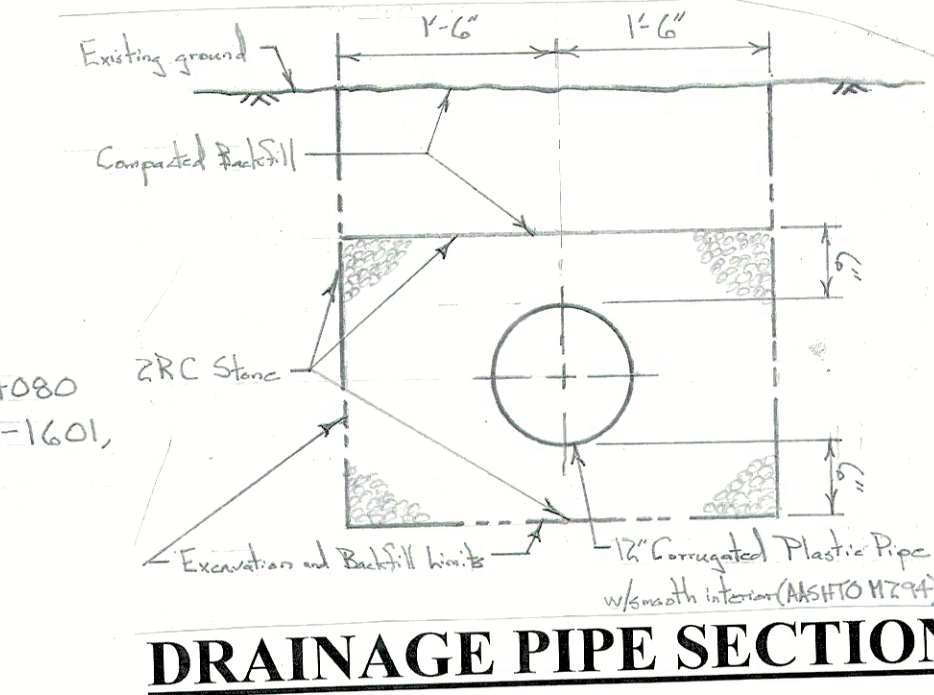

DRAINAGE PIPE SECTION

Scale: 1/4 in. = 1 ft.

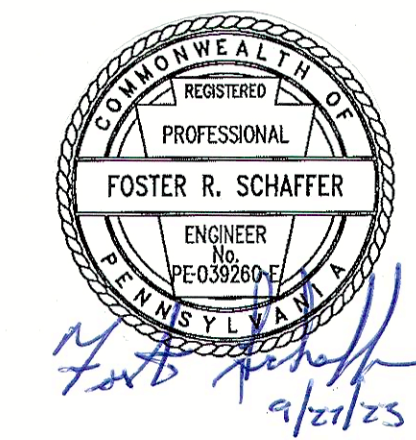

PENNSYLVANIA GAME COMMISSION		
SGL #77	SANDY TWP.	CLEARFIELD CO.
RIFLE / PISTOL RANGE PROJECT		
RANGE SECTIONS AND DRAINAGE PIPE PLAN		
REVISIONS	PROJECT NO.	PGC-77-23-02
▲	DRAWN BY:	FS
▲	DATE:	9/27/23
▲	SHEET NO.	3 OF 5